


Symbol	Description	Date	Approved

U. S. ARMY ENGINEERING AND SUPPORT CENTER, HUNTSVILLE HUNTSVILLE, ALABAMA	Date: 06 JAN 2009 Design file no. Drawing code:	Rev. 07 07
Designed by: JUAN PACE Drawn by: PACE Checked by: DUVERNEY Reviewed by: CE HMC-CD-SC-A Submitted by: CE HMC-CD-SC-A	File name: P:\01 order 30 Jan 2009 Plot scale: 1/8"=1'-0"	07

DA FACILITIES STANDARDIZATION PROGRAM
 ARMY FIRE STATION DESIGN GUIDE
 FOR
 SATELLITE FIRE STATION

Sheet reference number:
A4-SC
 Sheet 4 of 8

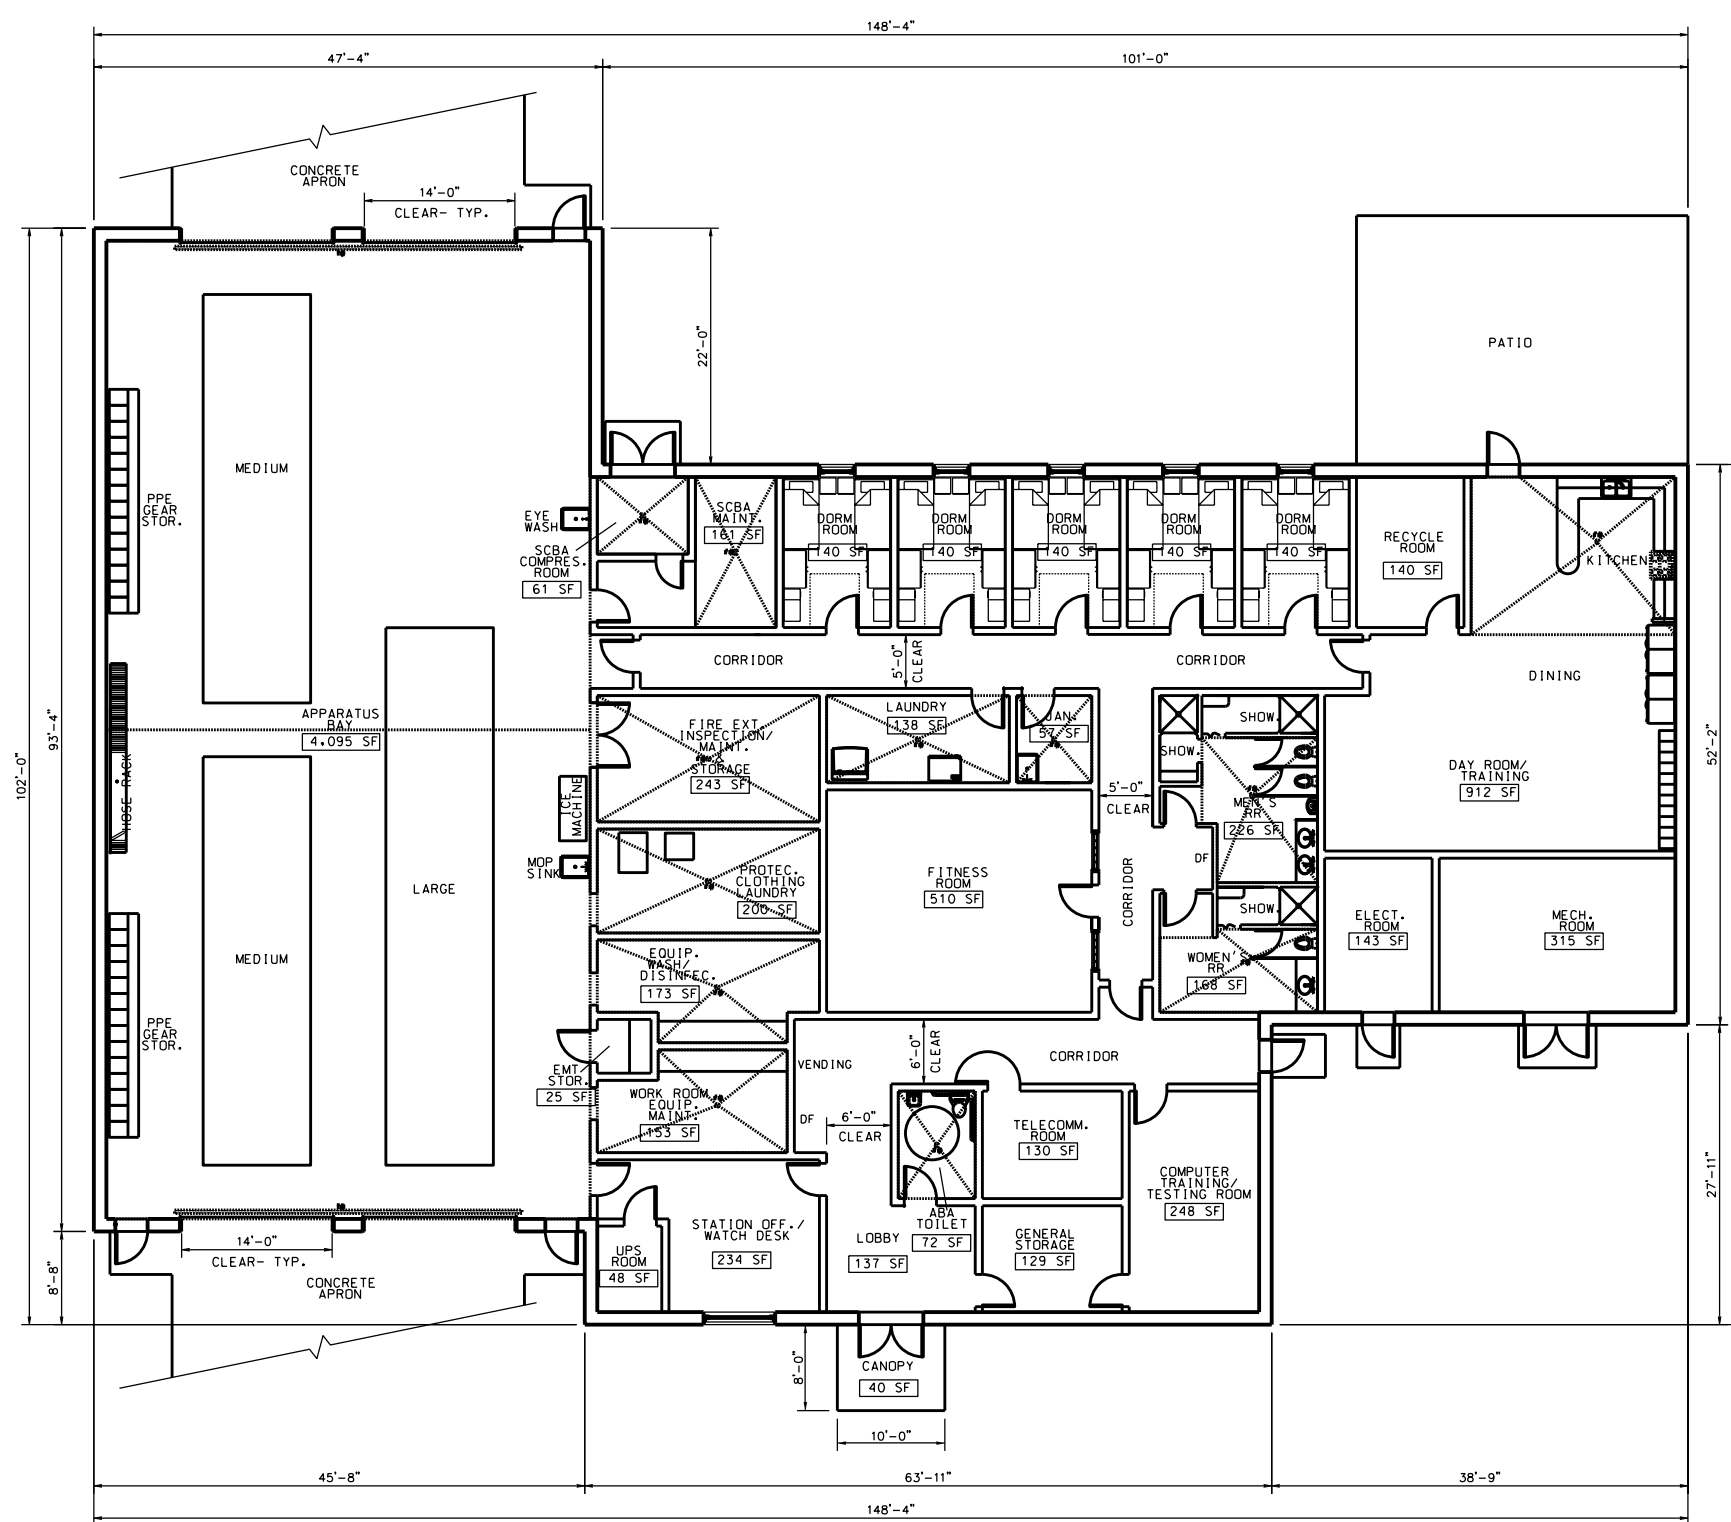

1 FLOOR PLAN
 ONE COMPANY SATELLITE FIRE STATION
 SCALE: 1' - 0" = 1/8" 11,471 SQ.FT.
 A4-SC

FIRST FLOOR= 11,431 SF
 CANOPY= 40 SF
 GROSS TOTAL= 11,471 SF

