


Symbol	Description	Date	Approved

Designed by: JUAN PACE	Checked by: DUNEIRAY	Date: 06 JAN 2009	Rev. 07
Drawn by: PACE	Reviewed by: CE MKC-ED-SC-A	Design file no. 	
	Submitted by: CE MKC-ED-SC-A	Drawing code: 	
		File name: 	
		Plot date: 30 JAN 2009	
		Plot scale: 1/8"=1'-0"	

DA FACILITIES STANDARDIZATION PROGRAM
 ARMY FIRE STATION DESIGN GUIDE
 FOR
 SATELLITE FIRE STATION

Sheet reference number:
A6-SC
 Sheet 6 of 8

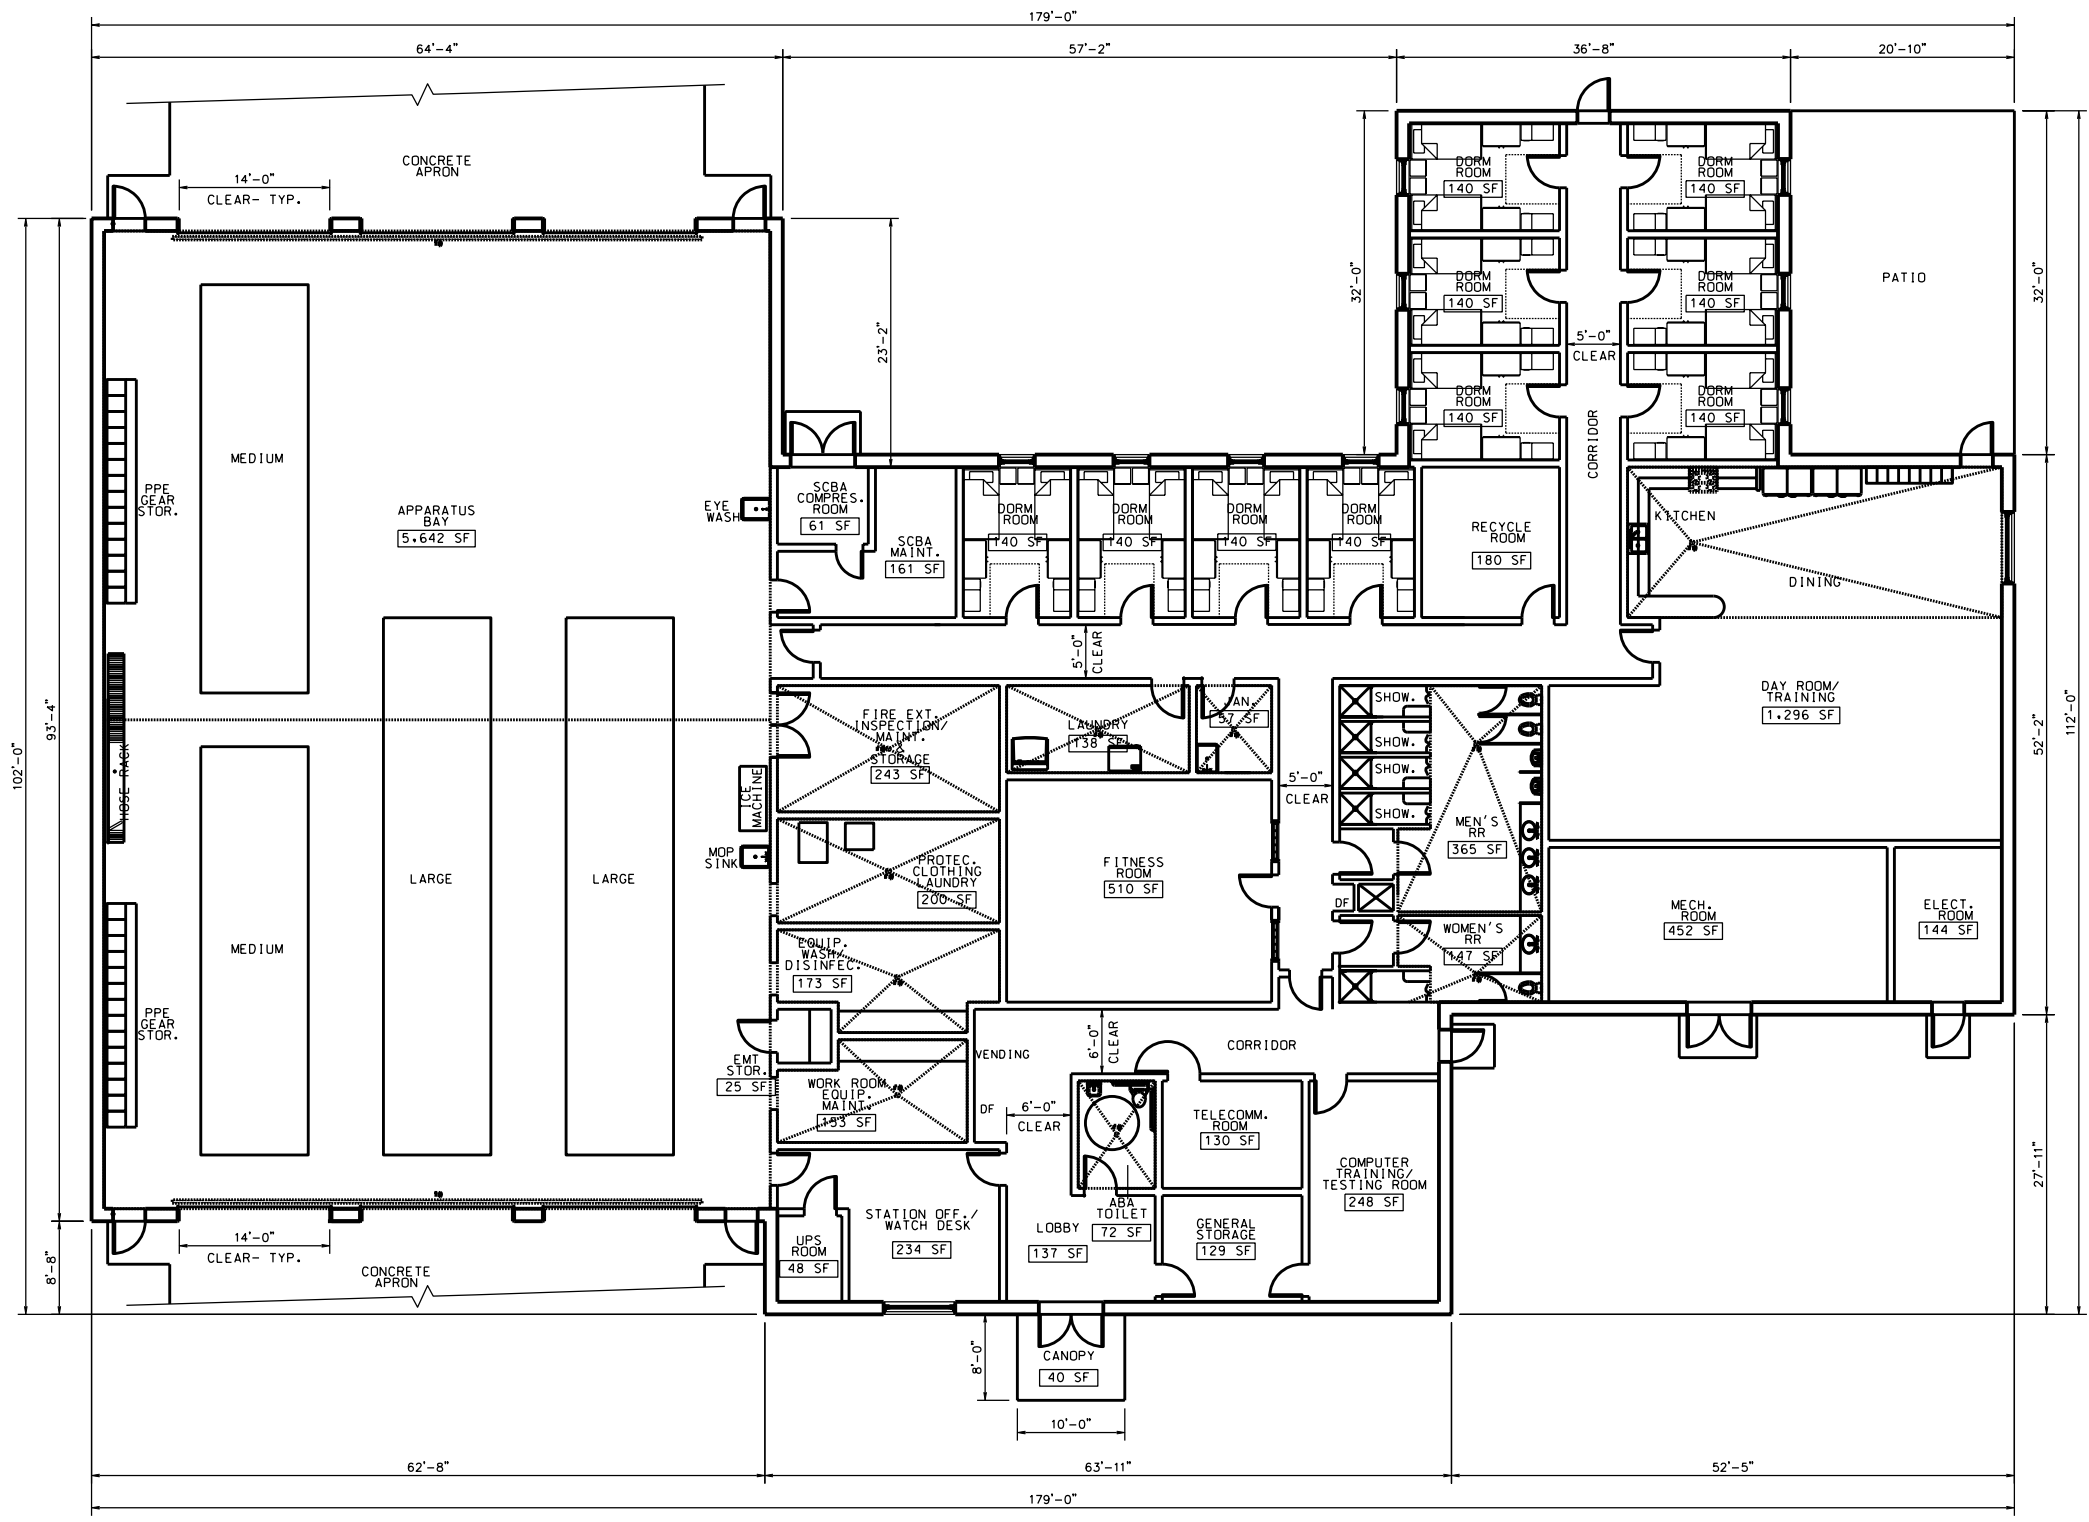

1
 A6-SC FLOOR PLAN
 TWO COMPANY SATELLITE FIRE STATION
 SCALE: 1' - 0" = 1/8" 14,943 SQ.FT.

FIRST FLOOR= 14,903 SF
 CANOPY= 40 SF
 GROSS TOTAL= 14,943 SF

