


5 4 3 2 1

D


C

B


A

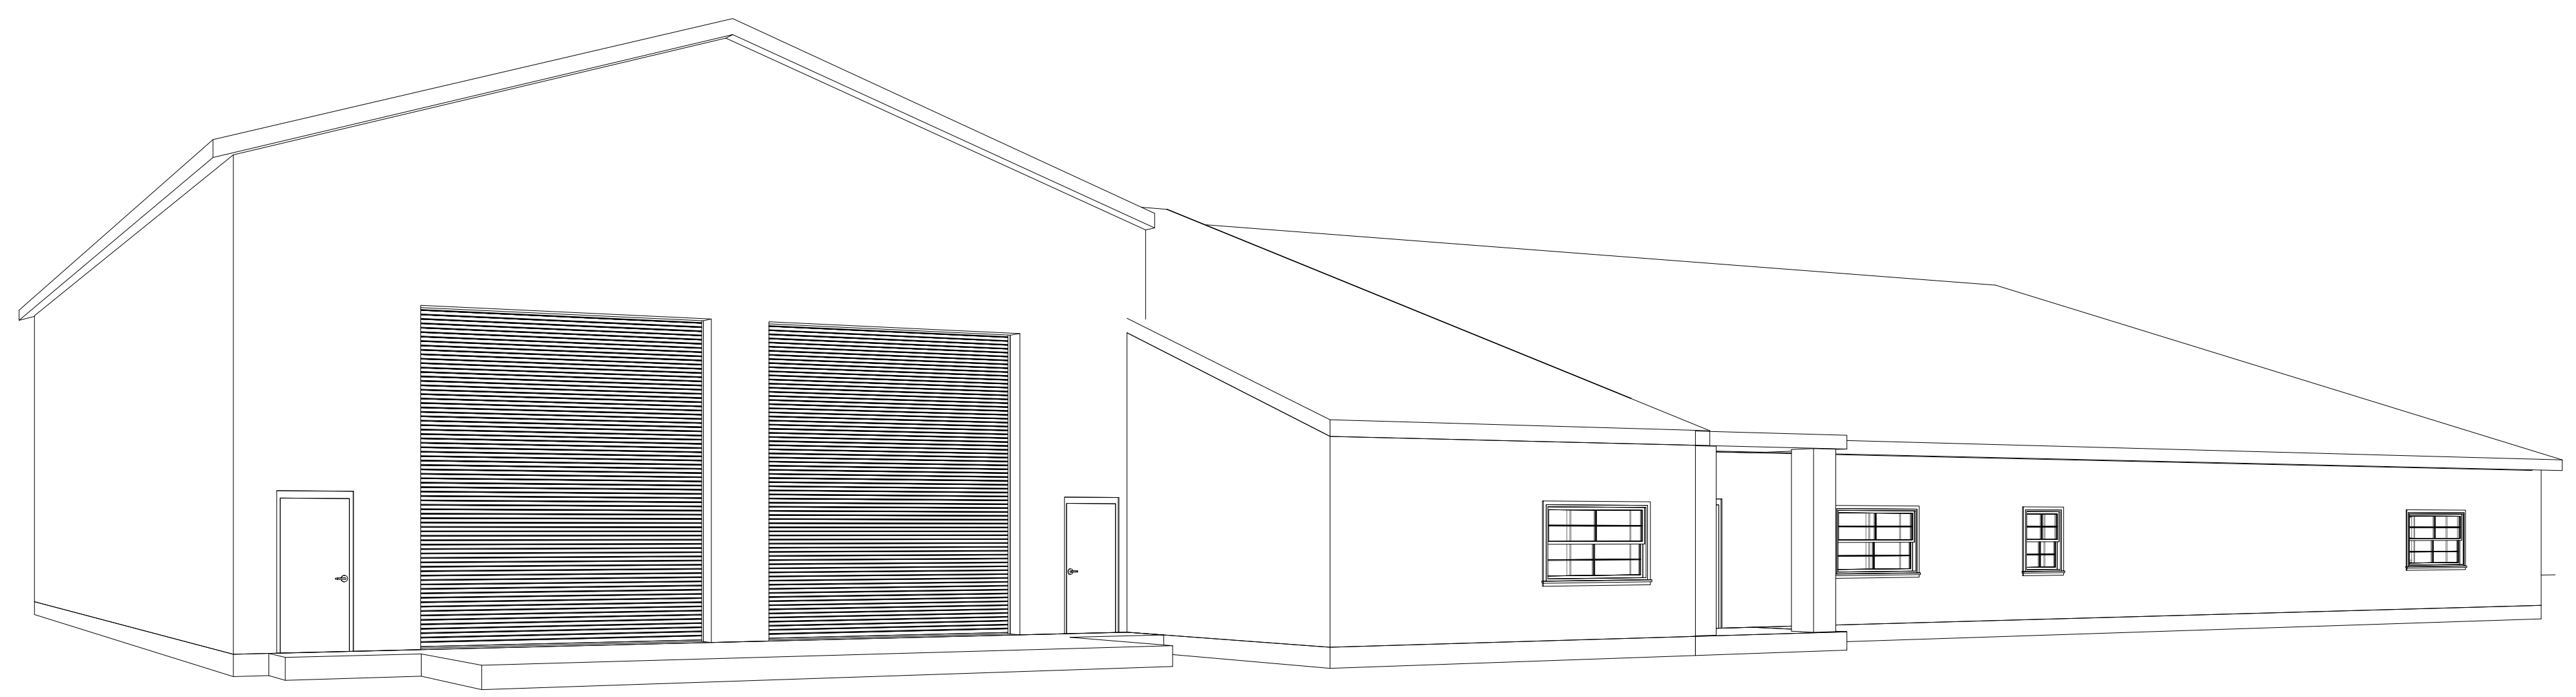

3D BUILDING PERSPECTIVE

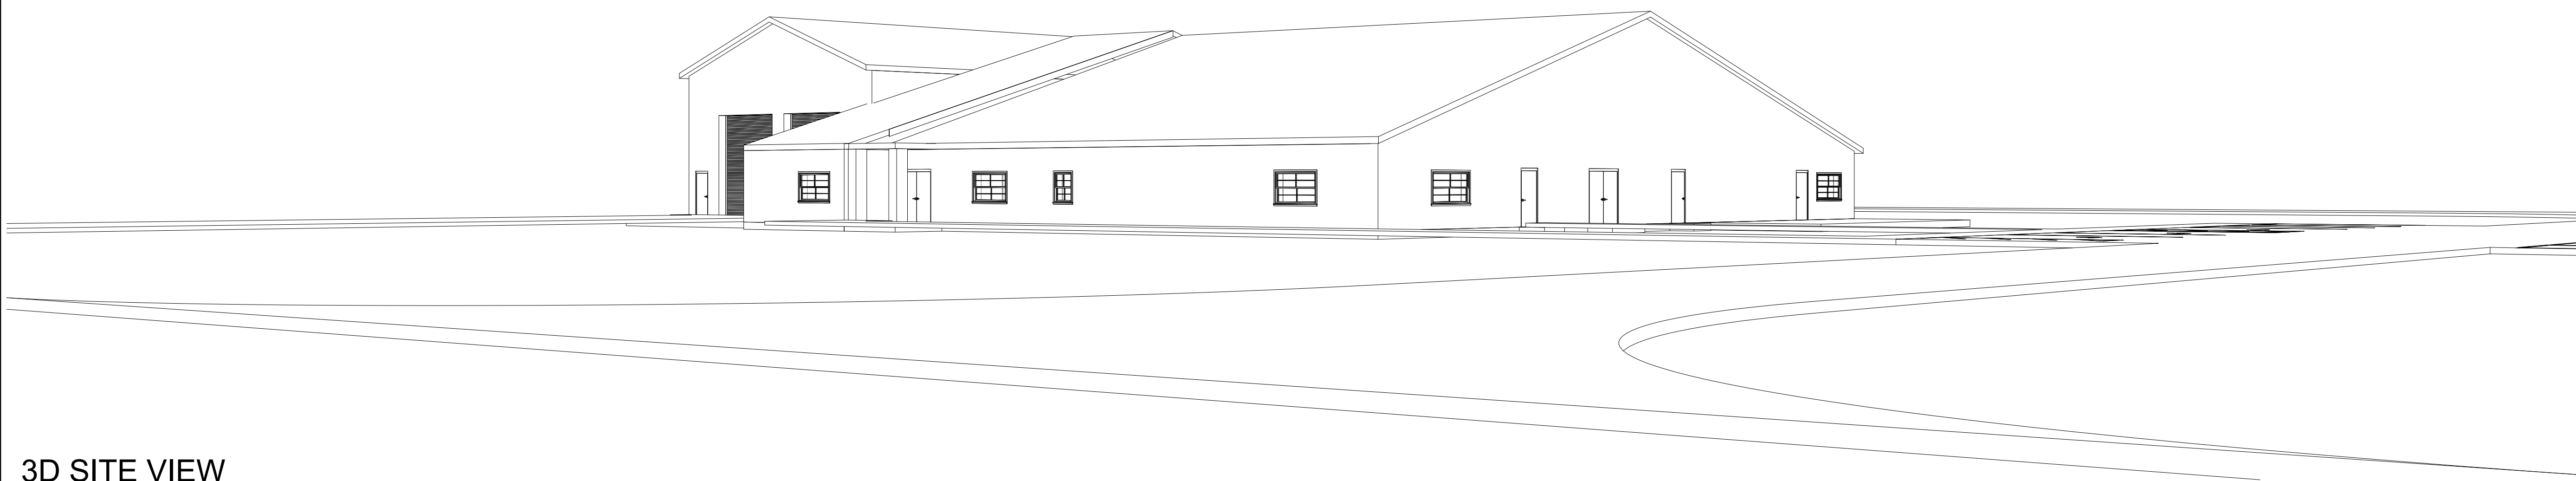

3D SITE VIEW

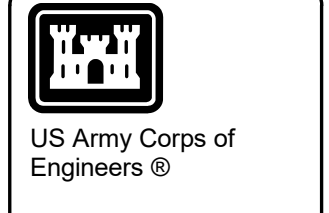

SYMBOL	DESCRIPTION	DATE	BY


DESIGN BY: Drew Author	DATE: SEPTEMBER 2021
CHK BY: 	SOLICITATION NO.: N/A
DRWN BY: 	CONTRACT NO.: N/A
SBMT BY: 	PLOT DATE: 9/23/2021
	PLOT SCALE: 9/51 41 AM
	FILE NAME:
	SIZE: 22" x 34"
U.S. ARMY CORPS OF ENGINEERS ENGINEERING AND SUPPORT CENTER	475 QUALITY CIRCLE HUNTSVILLE, AL 35896

DA FACILITIES STANDARDIZATION PROGRAM
ARMY FIRE STATION DESIGN GUIDE
ONE COMPANY HEADQUARTERS FIRE STATION

PERSPECTIVE VIEWS

PLATE REFERENCE NUMBER
A-801
SHEET

5 4 3 2 1

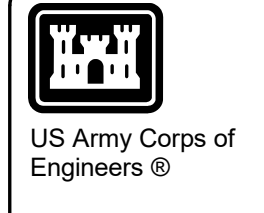

US Army Corps of Engineers ©


DATE	SYMBOL	DESCRIPTION	DATE	BY

DATE: SEPTEMBER 2021	SOLICITATION NO.: N/A	CONTRACT NO.: N/A	CATEGORY CODE:
DESIGN BY: U.S. ARMY CORPS OF ENGINEERS ENGINEERING AND SUPPORT CENTER	DRAWN BY: Author	CHK BY: Checker	FILE NAME:
475 QUALITY CIRCLE HUNTSVILLE, AL 35806	SEMT BY: 9/27/2021	PLOT DATE: 9/27/2021	FILE NAME:
	PLT SCALE: 1/8" = 1'-0"	PLOT SCALE: 1/8" = 1'-0"	SIZE: D 22" x 34"

DA FACILITIES STANDARDIZATION PROGRAM
 ARMY FIRE STATION DESIGN GUIDE
 ONE COMPANY HEADQUARTERS FIRE STATION

FLOOR PLAN

PLATE REFERENCE NUMBER
A-101
 SHEET

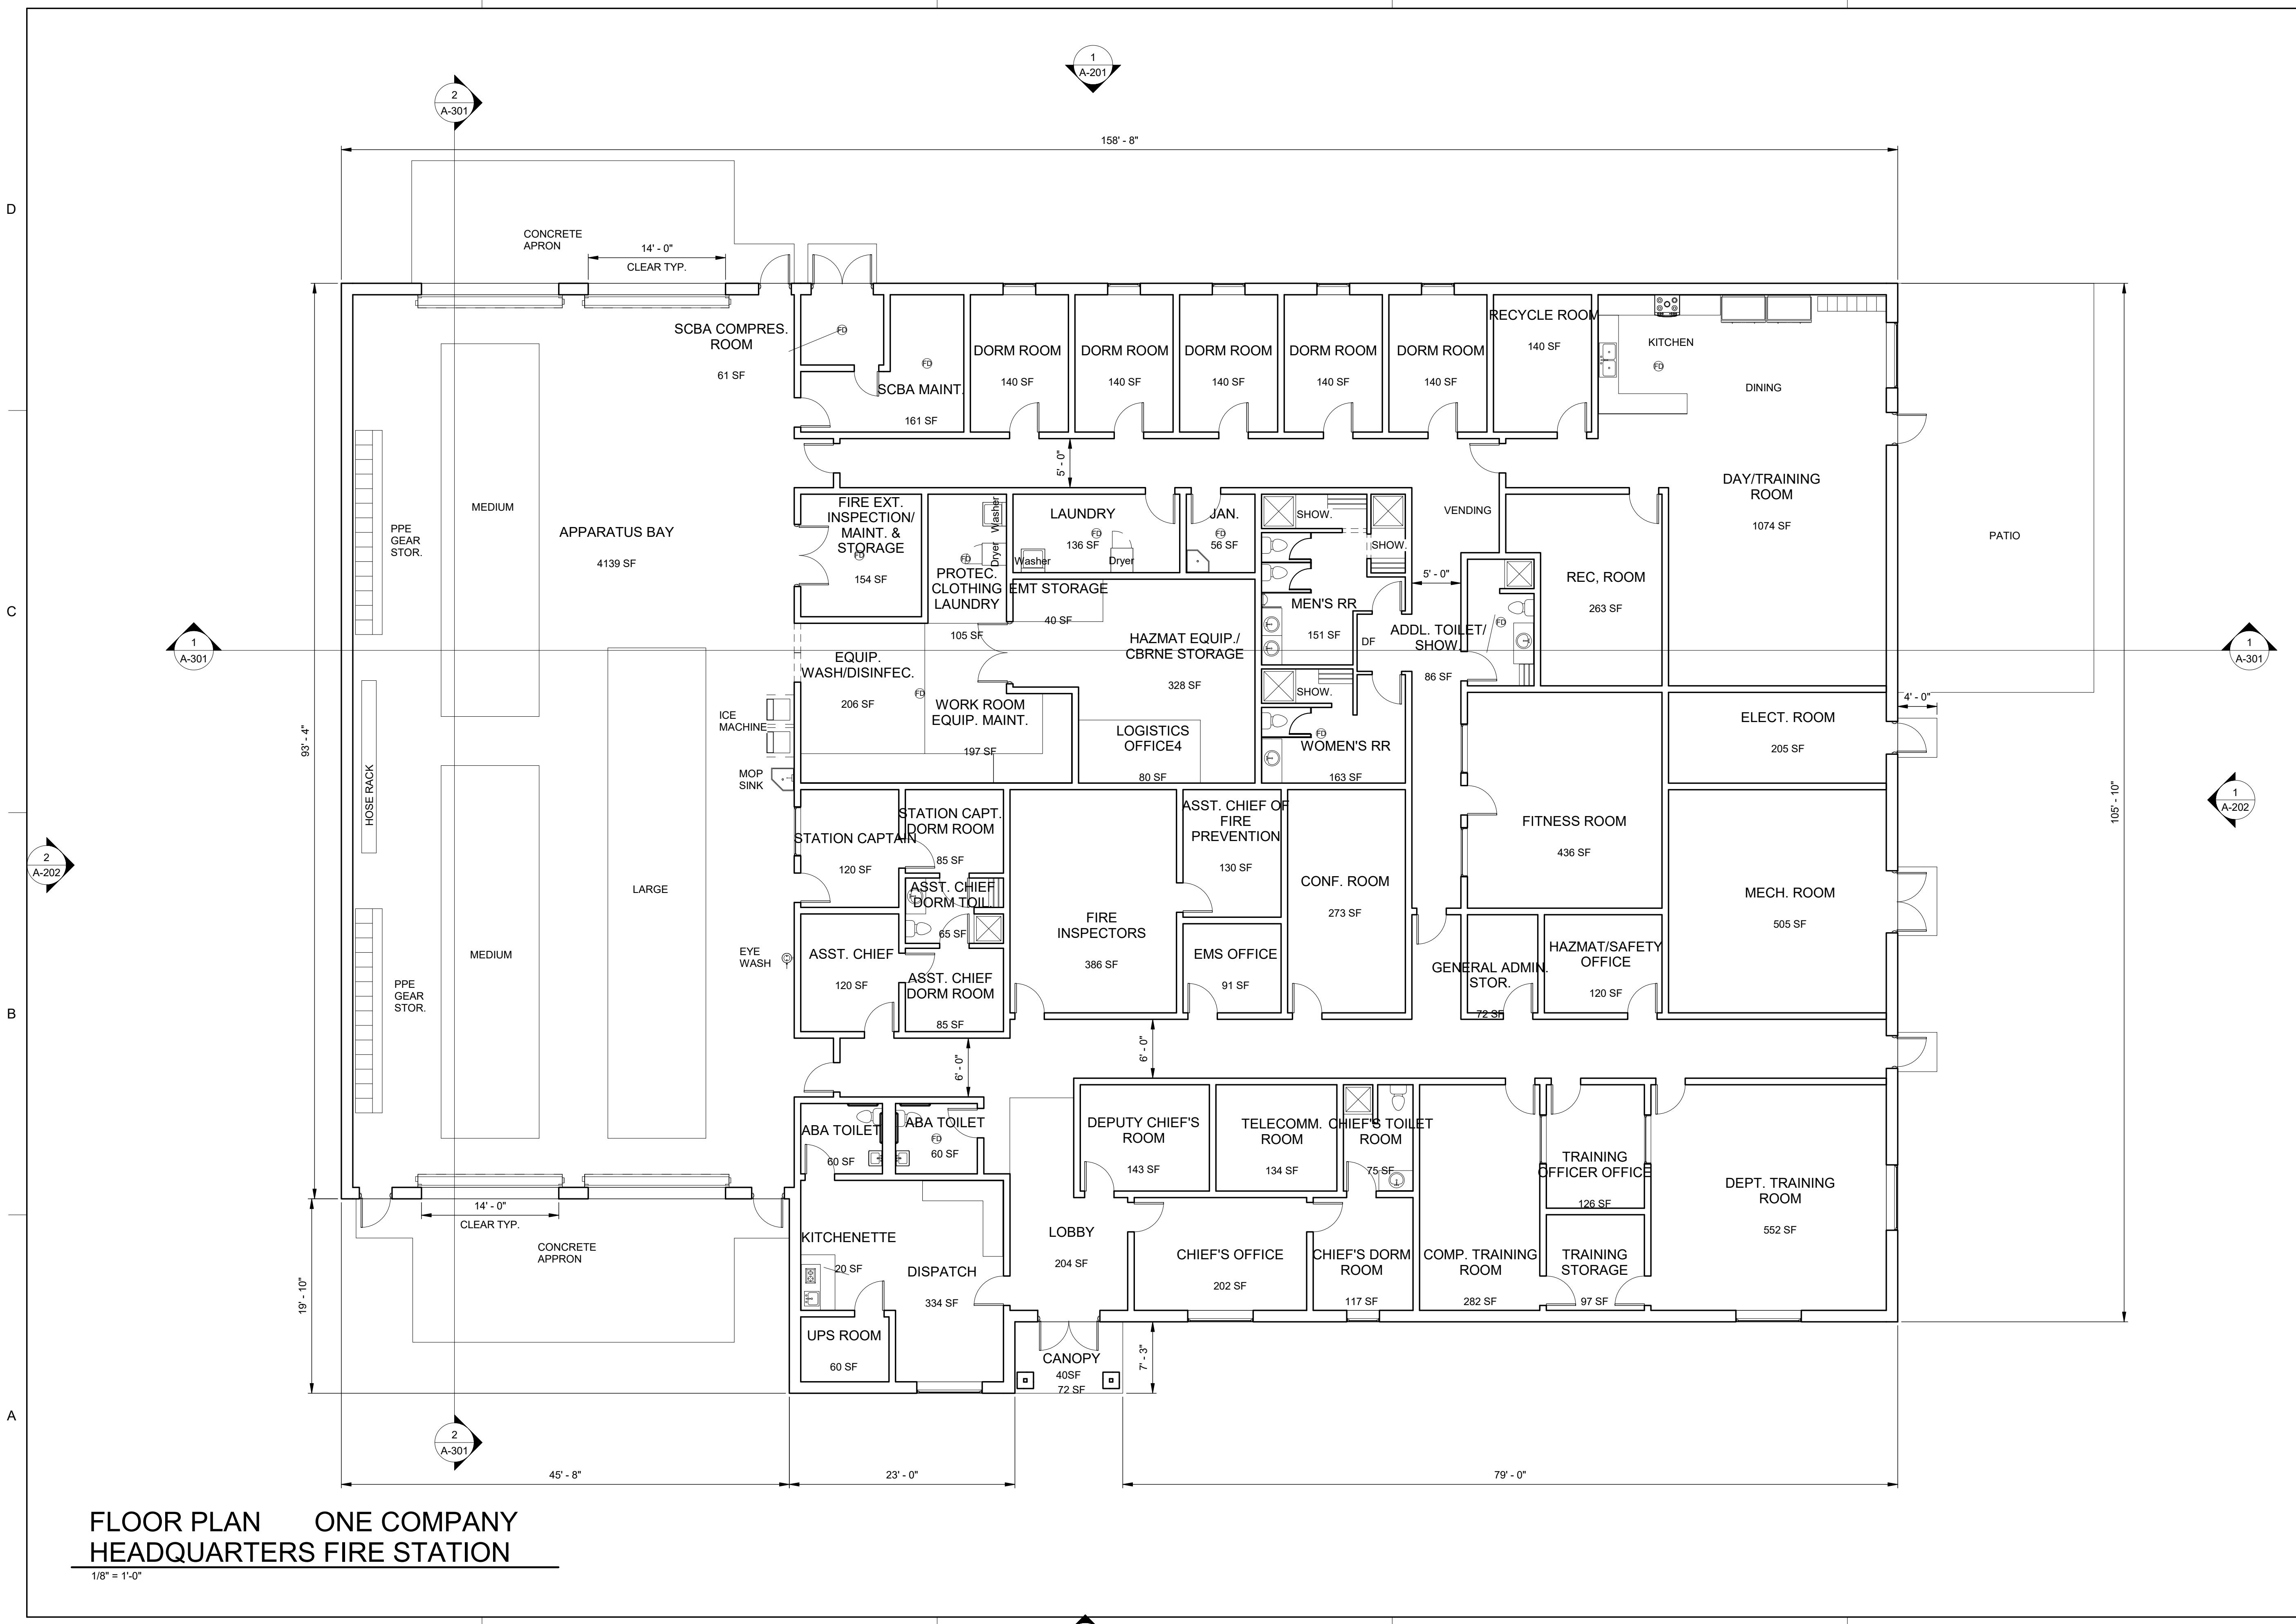

FLOOR PLAN ONE COMPANY HEADQUARTERS FIRE STATION

1/8" = 1'-0"

2 A-201

1 A-301

2 A-301

1 A-201

1 A-301


1 A-202

2 A-301



NORTH ELEVATION
1/8" = 1'-0"

SOUTH ELEVATION
1/8" = 1'-0"

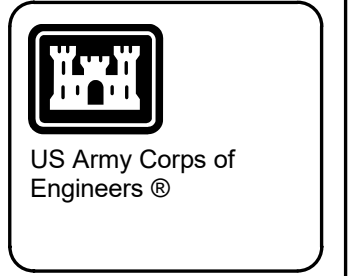


SYMBOL	DESCRIPTION	DATE	BY

U.S. ARMY CORPS OF ENGINEERS ENGINEERING AND SUPPORT CENTER	DESIGN BY: Design Author	DATE: SEPTEMBER 2021
475 QUALITY CIRCLE HUNTSVILLE, AL 35896	CHK BY: Checker	SOLICITATION NO.: N/A
	DESIGN BY: Author	CONTRACT NO.: N/A
	SRMT BY: Approver	DATE: 9/22/2021
	PLOT SCALE: 1/8" = 1'-0"	FILE NAME: 22' x 34'
	PLOT DATE: 9/22/2021	CATEGORY CODE:

DA FACILITIES STANDARDIZATION PROGRAM
ARMY FIRE STATION DESIGN GUIDE
ONE COMPANY HEADQUARTERS FIRE STATION

NORTH AND SOUTH ELEVATIONS

PLATE REFERENCE NUMBER
A-201
SHEET

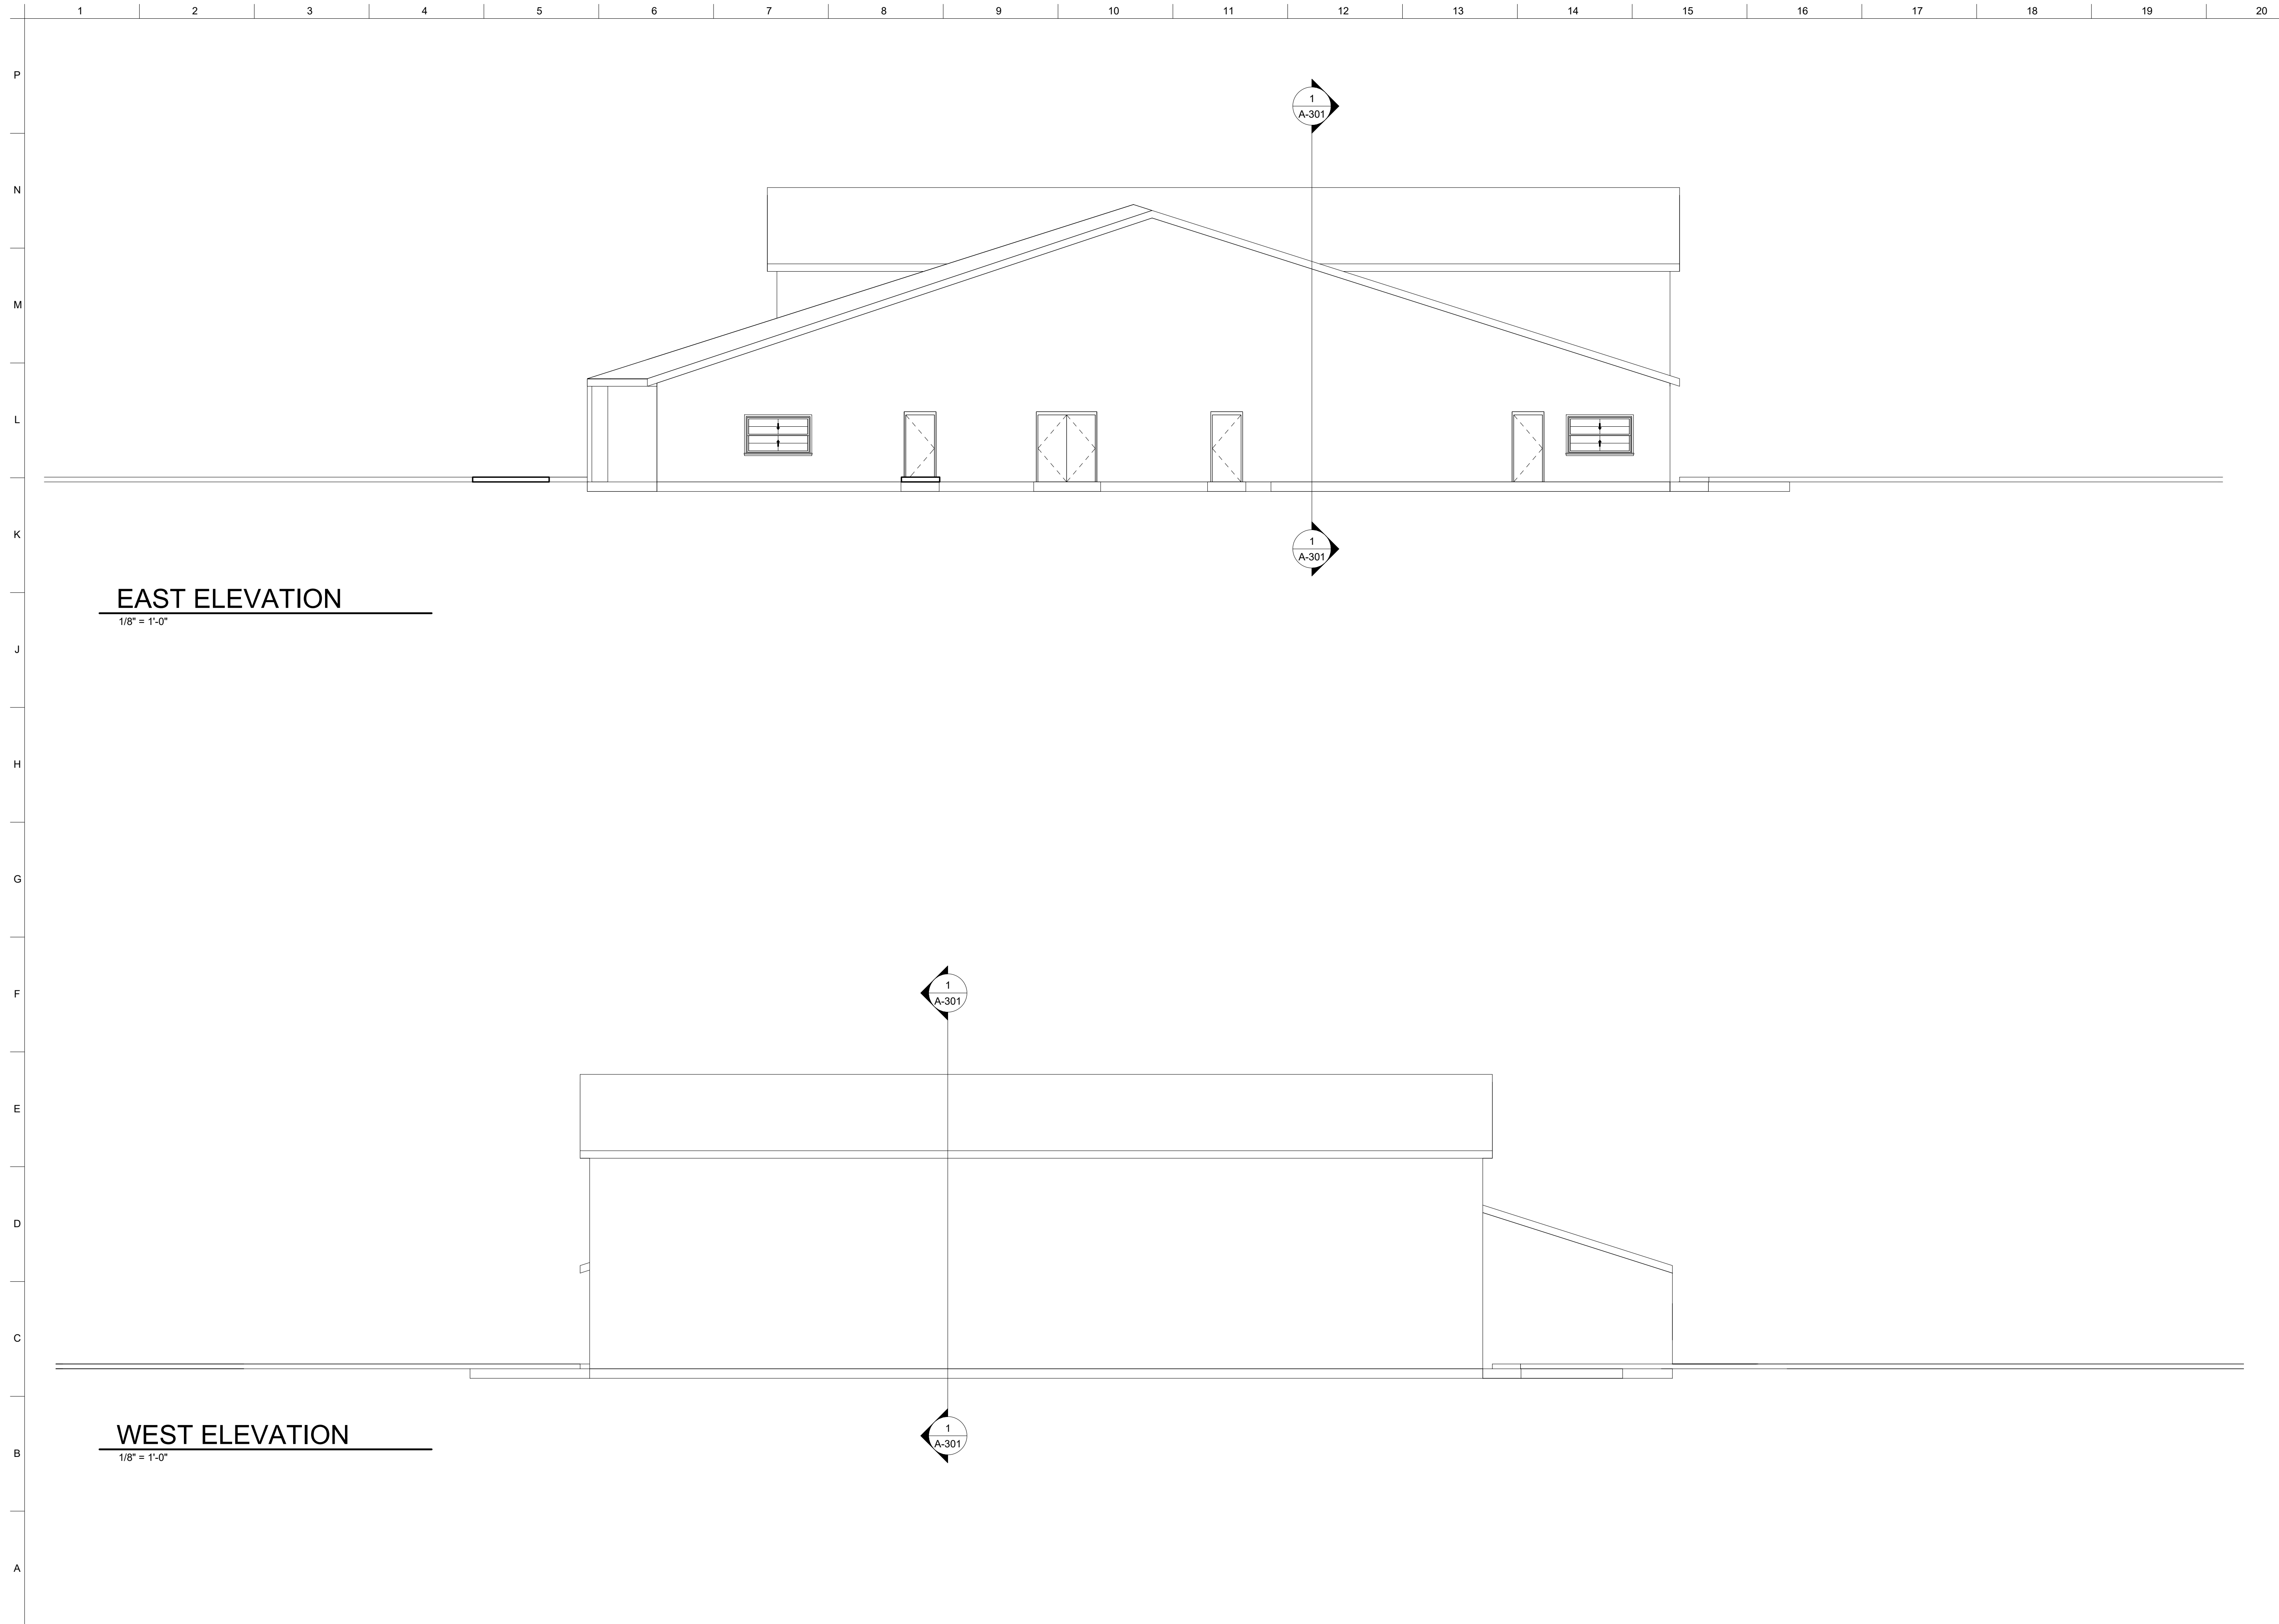

EAST ELEVATION

1/8" = 1'-0"

WEST ELEVATION

1/8" = 1'-0"



MARK	DESCRIPTION	DATE

DESIGNED BY:	ISSUE DATE:
DESIGNER:	Issue Date:
DRAWN BY:	SOLICITATION NO.:
AUTHOR:	CONTRACT NO.:
CHECKED BY:	CHECKER:
SUBMITTED BY:	SUBMITTED BY:
SIZE:	ANSI D

US ARMY CORPS OF ENGINEERS
ENGINEERING & SUPPORT CENTER

475 QUALITY CIRCLE
HUNTSVILLE, AL

Enter address here
DA FACILITIES STANDARDIZATION PROGRAM
Project Number

EAST AND WEST ELEVATIONS

SHEET ID

A-202

5

4

3

2


1

D

C


B

A

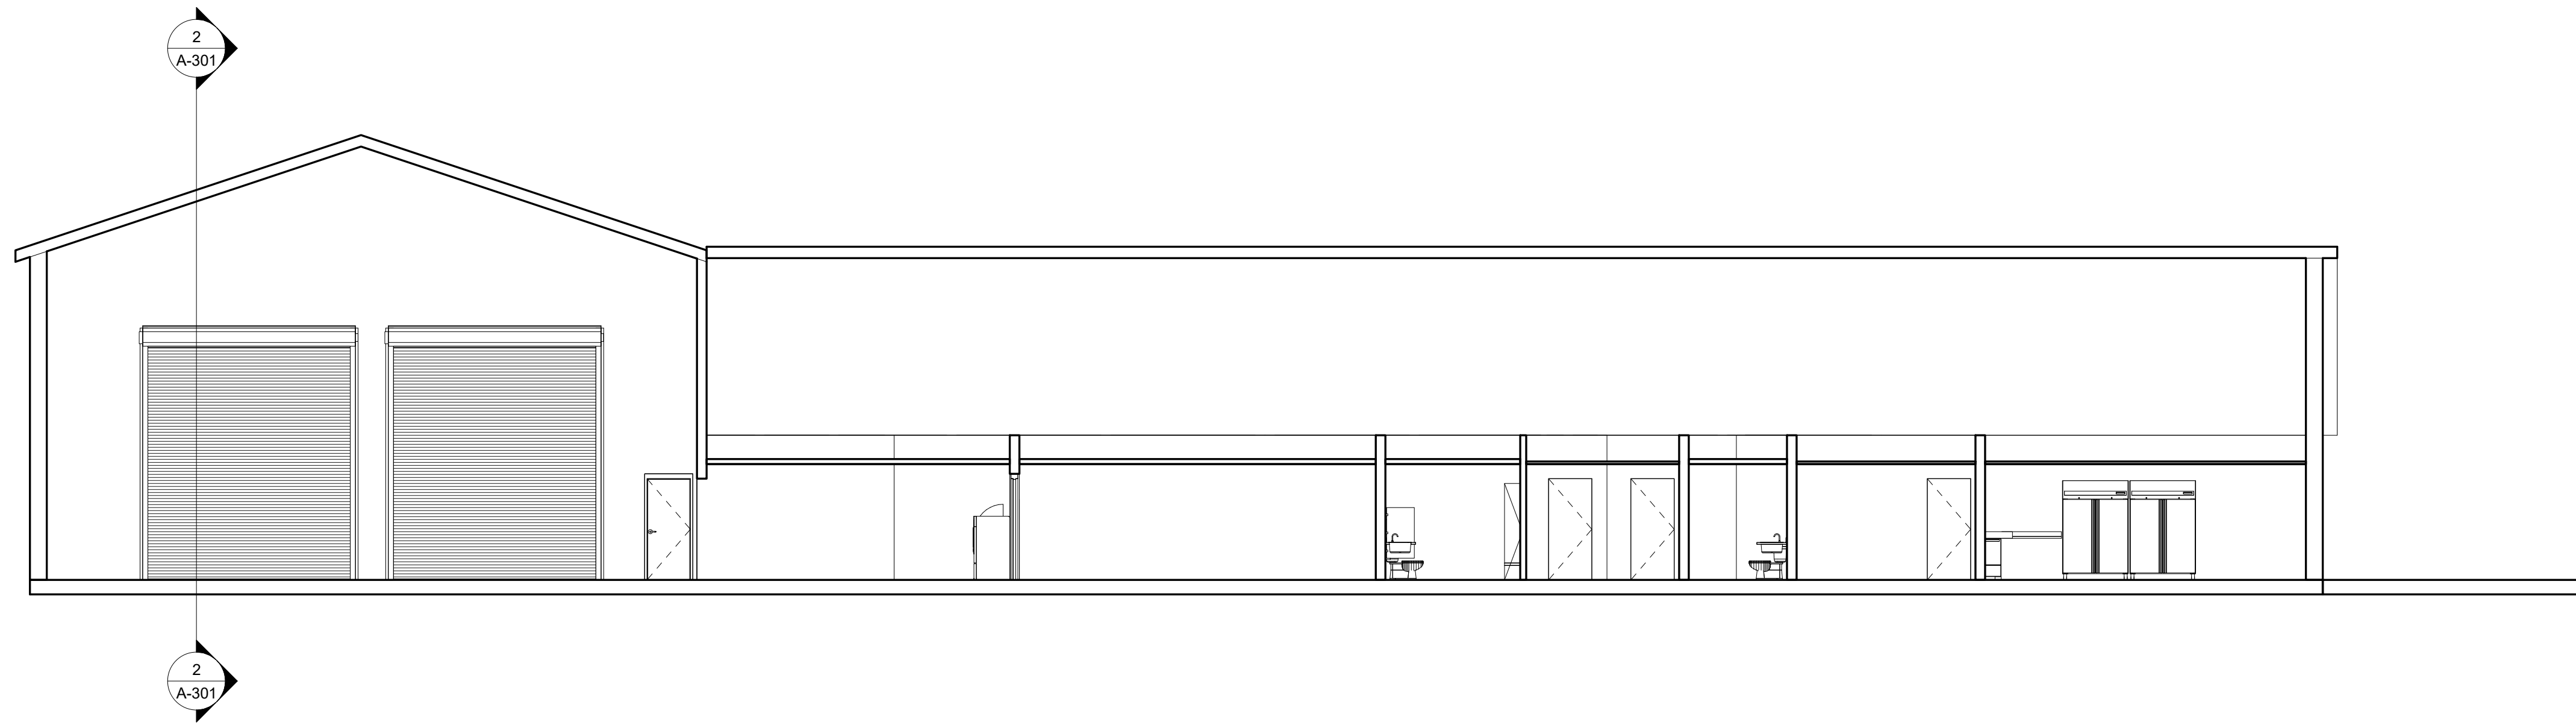


BUILDING CROSS SECTION 1

1/8" = 1'-0"

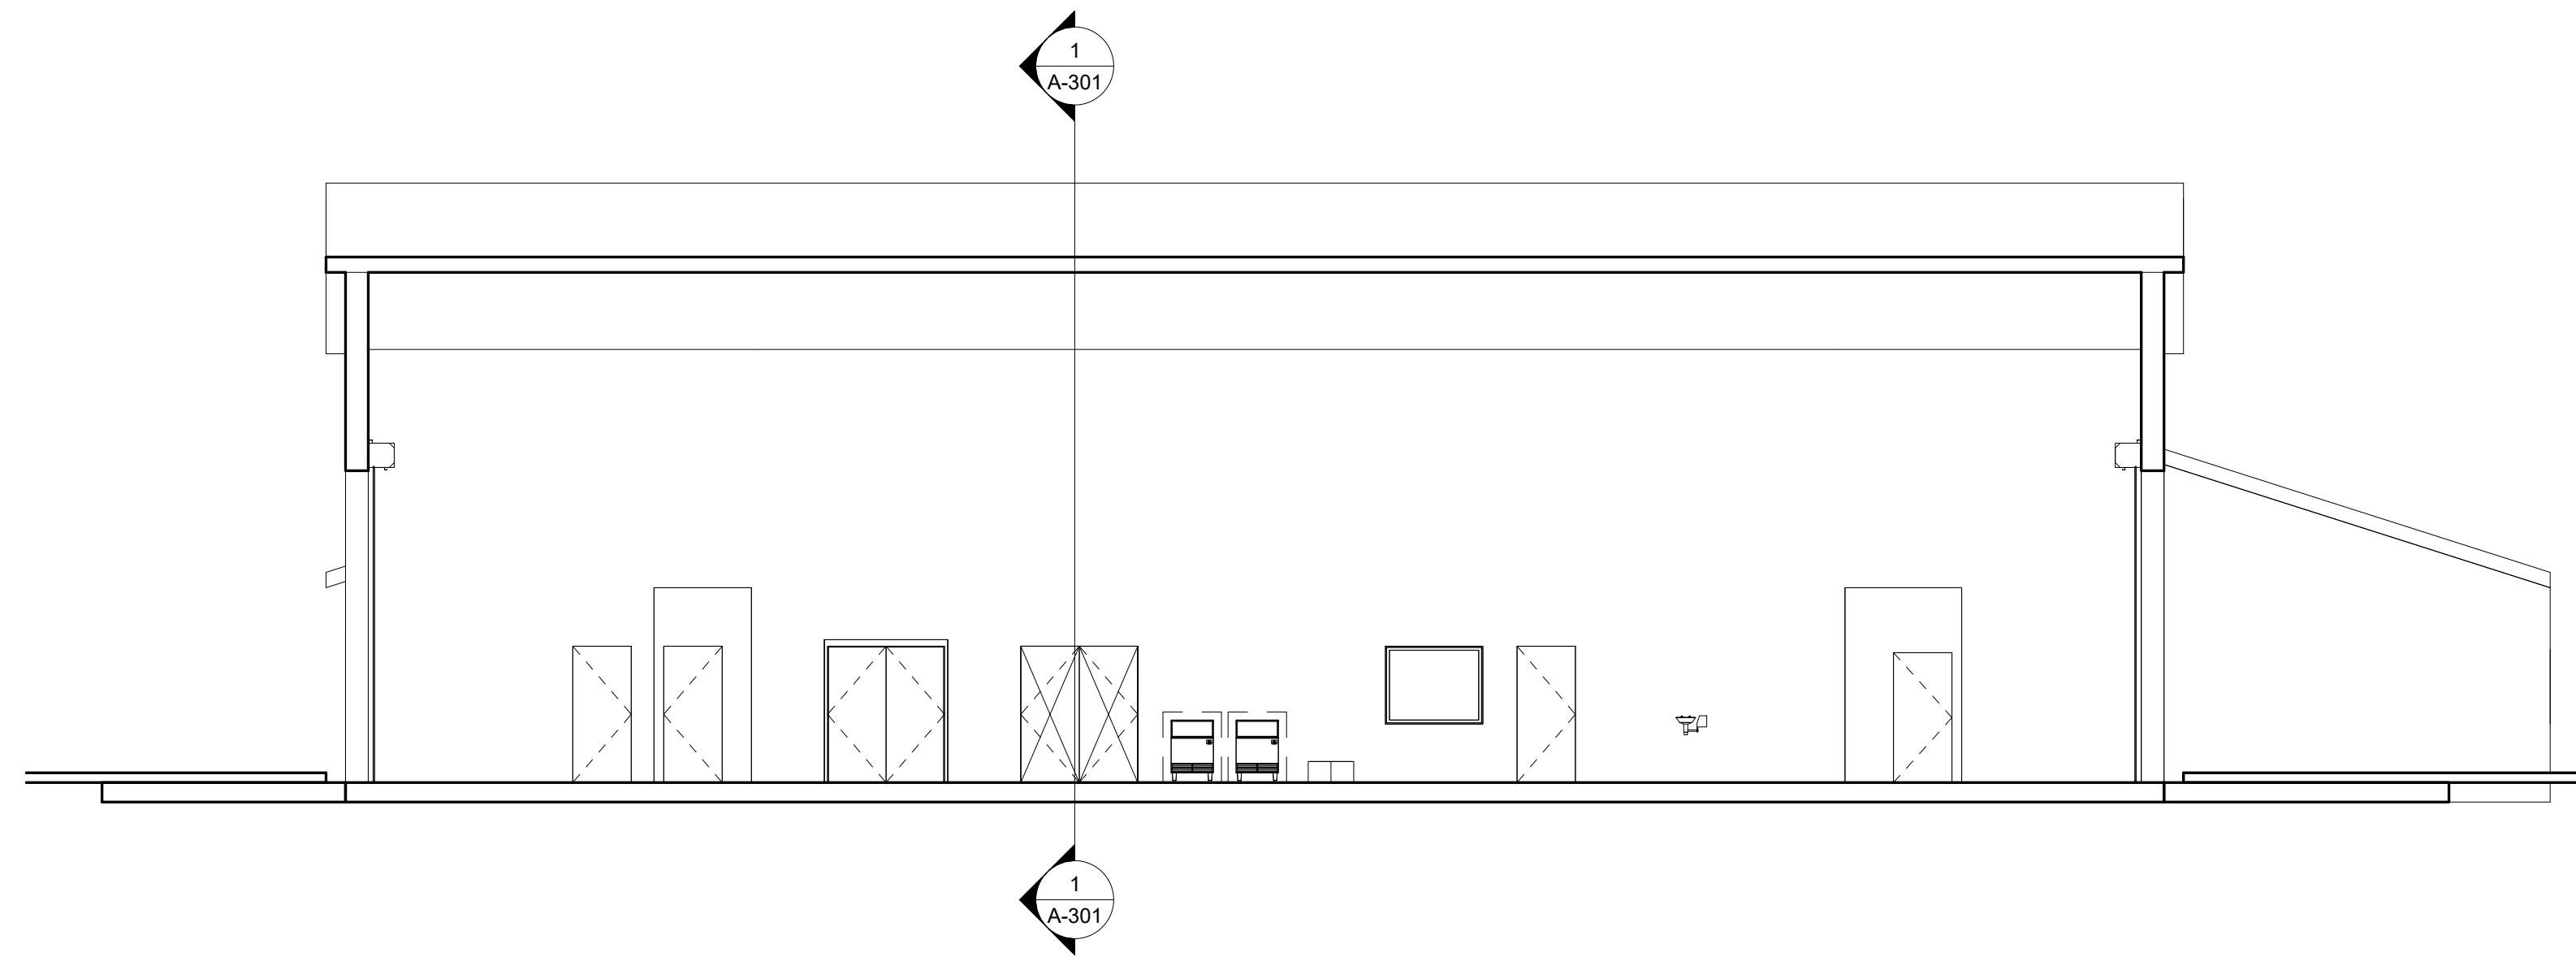

BUILDING CROSS SECTION 2

1/8" = 1'-0"

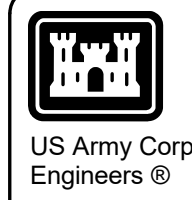

US Army Corps of
Engineers ®

SYMBOL	DESCRIPTION	DATE	BY

DATE: SEPTEMBER 2021	SOLICITATION NO.: N/A	CONTRACT NO.: N/A	CATEGORY CODE:
DESIGN BY: Drafting	CHK BY: Checker	PILOT DATE: 9/22/2021	FILE NAME:
DRAWN BY: Author	APPROVED BY: Approver	PILOT SCALE: 1/8" = 1'-0"	SIZE: D 22" x 34"
U.S. ARMY CORPS OF ENGINEERS ENGINEERING AND SUPPORT CENTER 475 QUALITY CIRCLE HUNTSVILLE, AL 35896			

DA FACILITIES STANDARDIZATION PROGRAM
ARMY FIRE STATION DESIGN GUIDE
ONE COMPANY HEADQUARTERS FIRE STATION
BUILDING CROSS SECTION

PLATE
REFERENCE
NUMBER
A-301
SHEET

D

C

B

A



US Army Corps of Engineers ©

SYMBOL	DESCRIPTION	DATE	BY

U.S. ARMY CORPS OF ENGINEERS ENGINEERING AND SUPPORT CENTER			
DESIGN BY:		DATE:	SEPTEMBER 2021
DRAWN BY:	CHK BY:	SOLICITATION NO.:	N/A
AUTHOR:	CHECKER:	CONTRACT NO.:	N/A
DESIGNED BY:	APPROVER:	PLOT DATE:	9/22/2021
475 QUALITY CIRCLE	HUNTSVILLE, AL 35896	PLOT SCALE:	5:34:19 PM
		FILE NAME:	
		SIZE:	D 22" x 34"

DA FACILITIES STANDARDIZATION PROGRAM
ARMY FIRE STATION DESIGN GUIDE
ONE COMPANY HEADQUARTERS FIRE STATION

SITE PLAN

PLATE
REFERENCE
NUMBER
C-101
SHEET

SITE PLAN
1" = 20'-0"

MAIN STREET

