

US Army Corps of
Engineers®
Omaha District

LARGE CHAPEL

3D BIM - ARMY STANDARD DESIGN


BASIC MINISTRY SERIES

VARIOUS LOCATIONS (CONUS)


DRAWING INDEX		
SHEET NUMBER	SHEET ORDER	SHEET TITLE
G-101	1	COVER SHEET AND INDEX
C-101	2	COMPOSITE SITE PLAN ALT-1
C-102	3	COMPOSITE SITE PLAN ALT-2
A-110	4	COMPOSITE FIRST FLOOR PLAN
A-120	5	COMPOSITE SECOND FLOOR PLAN
A-300	6	BUILDING SECTION AND INTERIOR ELEVATION
I-110	7	COMPOSITE FIRST FLOOR FURNITURE PLAN
I-120	8	COMPOSITE SECOND FLOOR FURNITURE PLAN

1 2 3 4 5

D
C
B
A

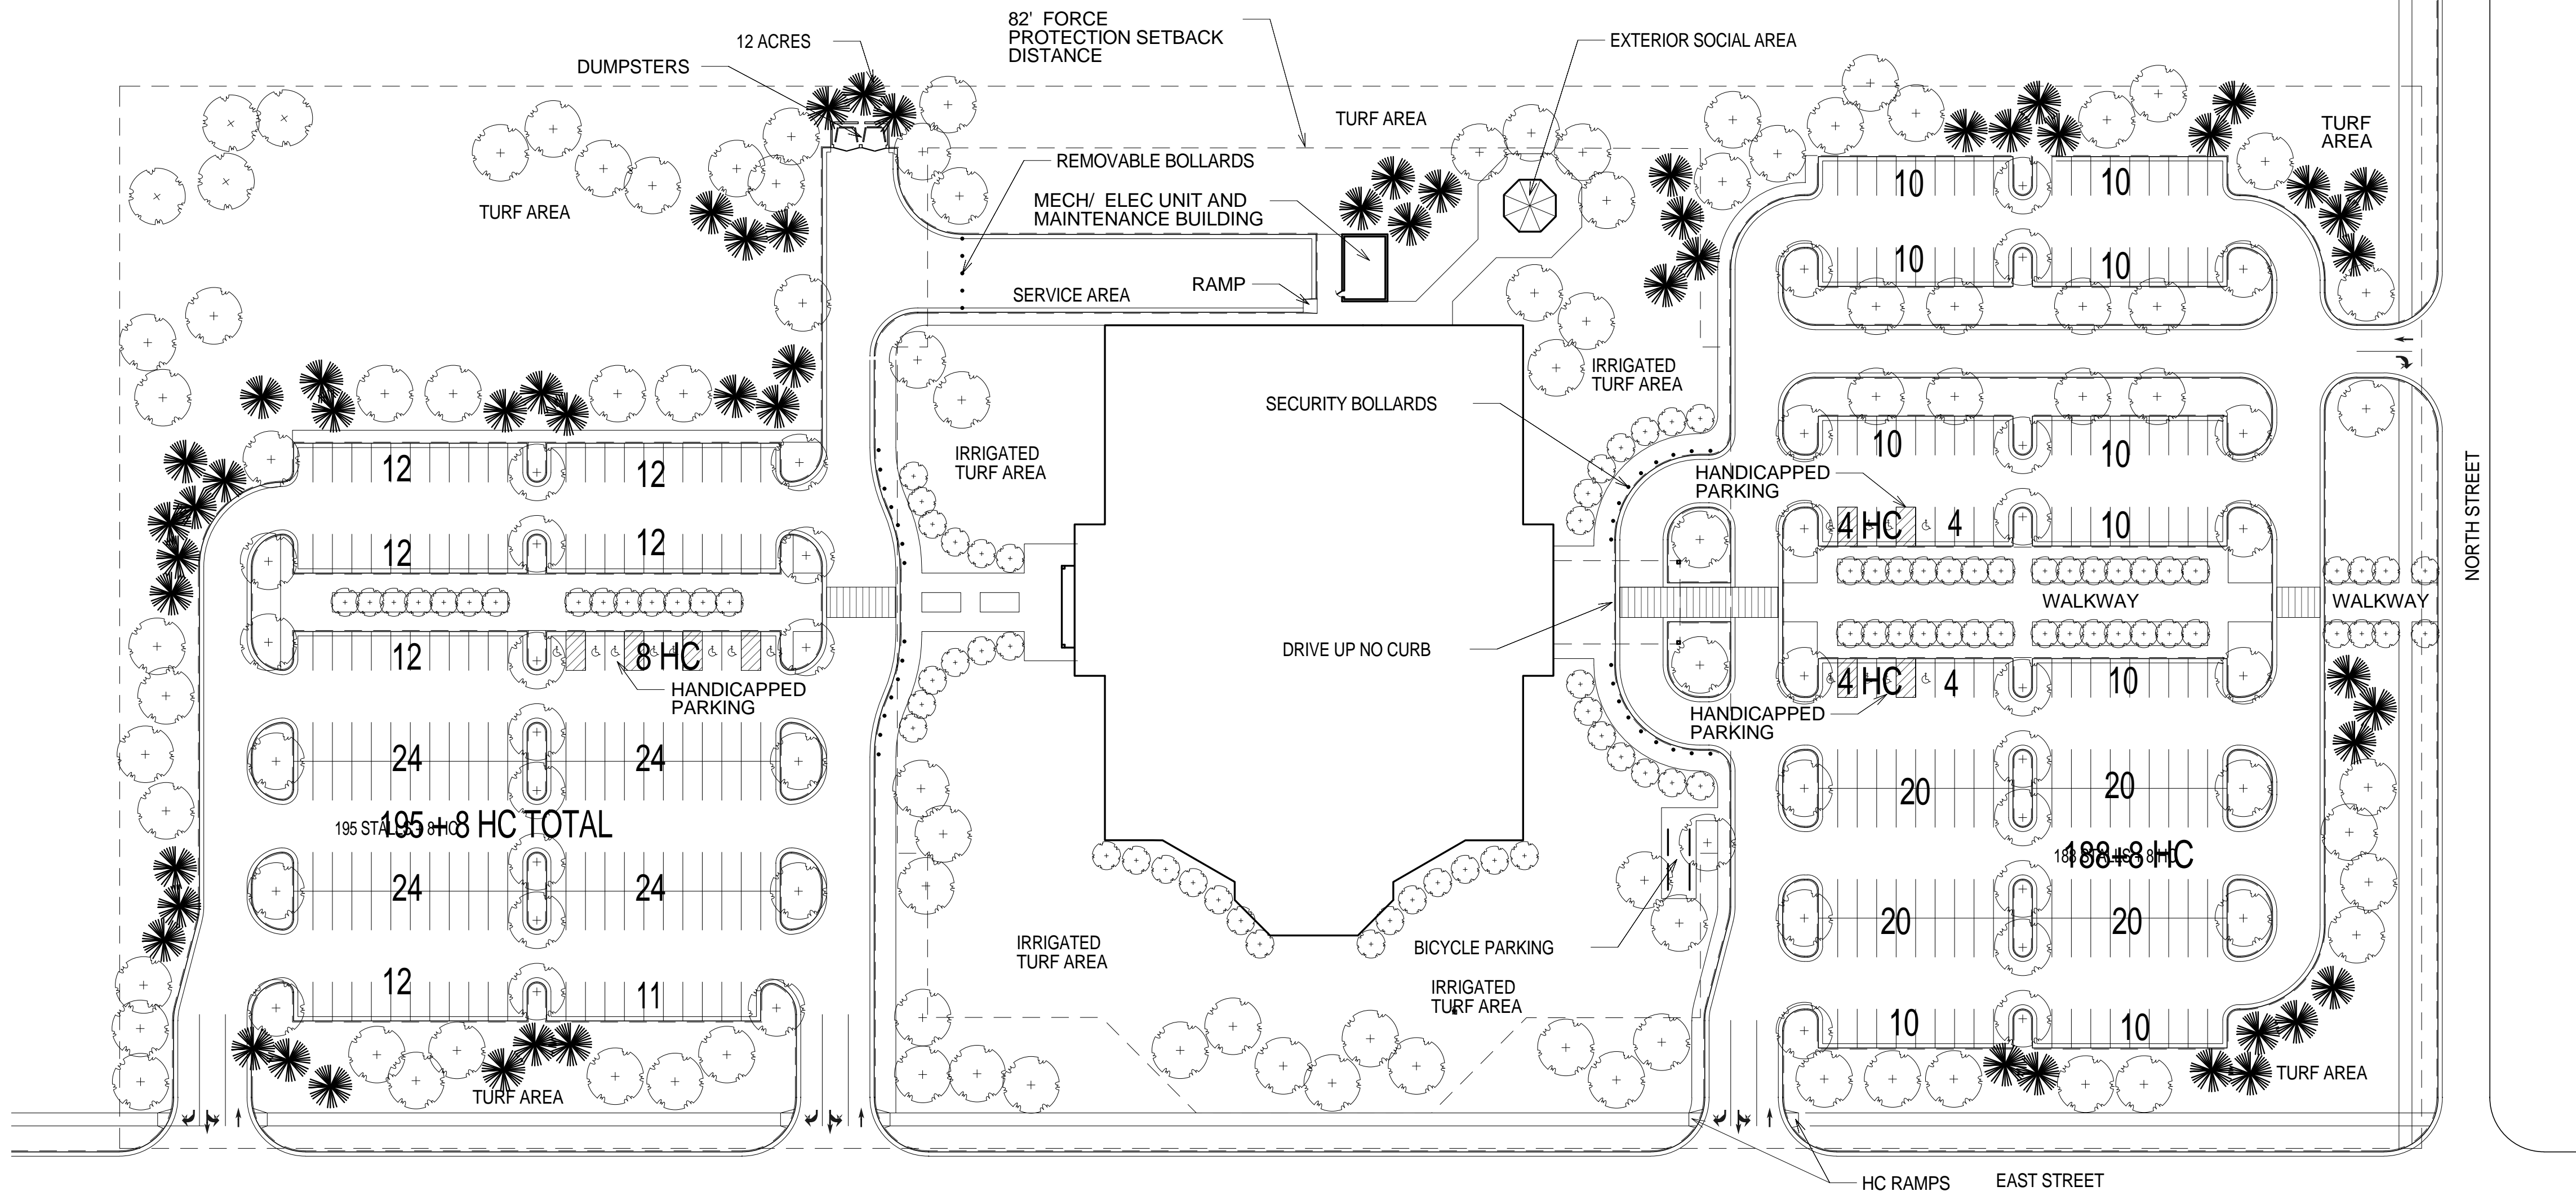

1
COMPOSITE SITE PLAN ALT-1
 C-101 1" = 50'-0"

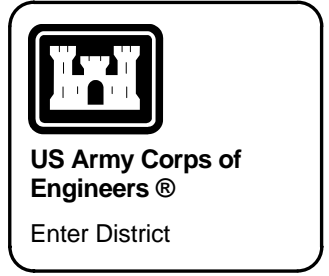

MARK	DESCRIPTION	DATE	APPR

DESIGN BY:	ISSUE DATE:
DRAWN BY:	CHECKED BY:
DATE:	DATE:
SCALE:	SCALE:
FILE NAME:	FILE NUMBER:


US ARMY CORPS OF ENGINEERS
 OMAHA DISTRICT

LARGE CHAPEL
 3D BIM - ARMY STANDARD DESIGN
 VARIOUS LOCATIONS (CONUS)
 BASIC MINISTRY SERIES
 COMPOSITE SITE PLAN ALT-1

SHEET IDENTIFICATION
C-101
 SHEET 2 OF 0

C-101-

17.8 ACRES

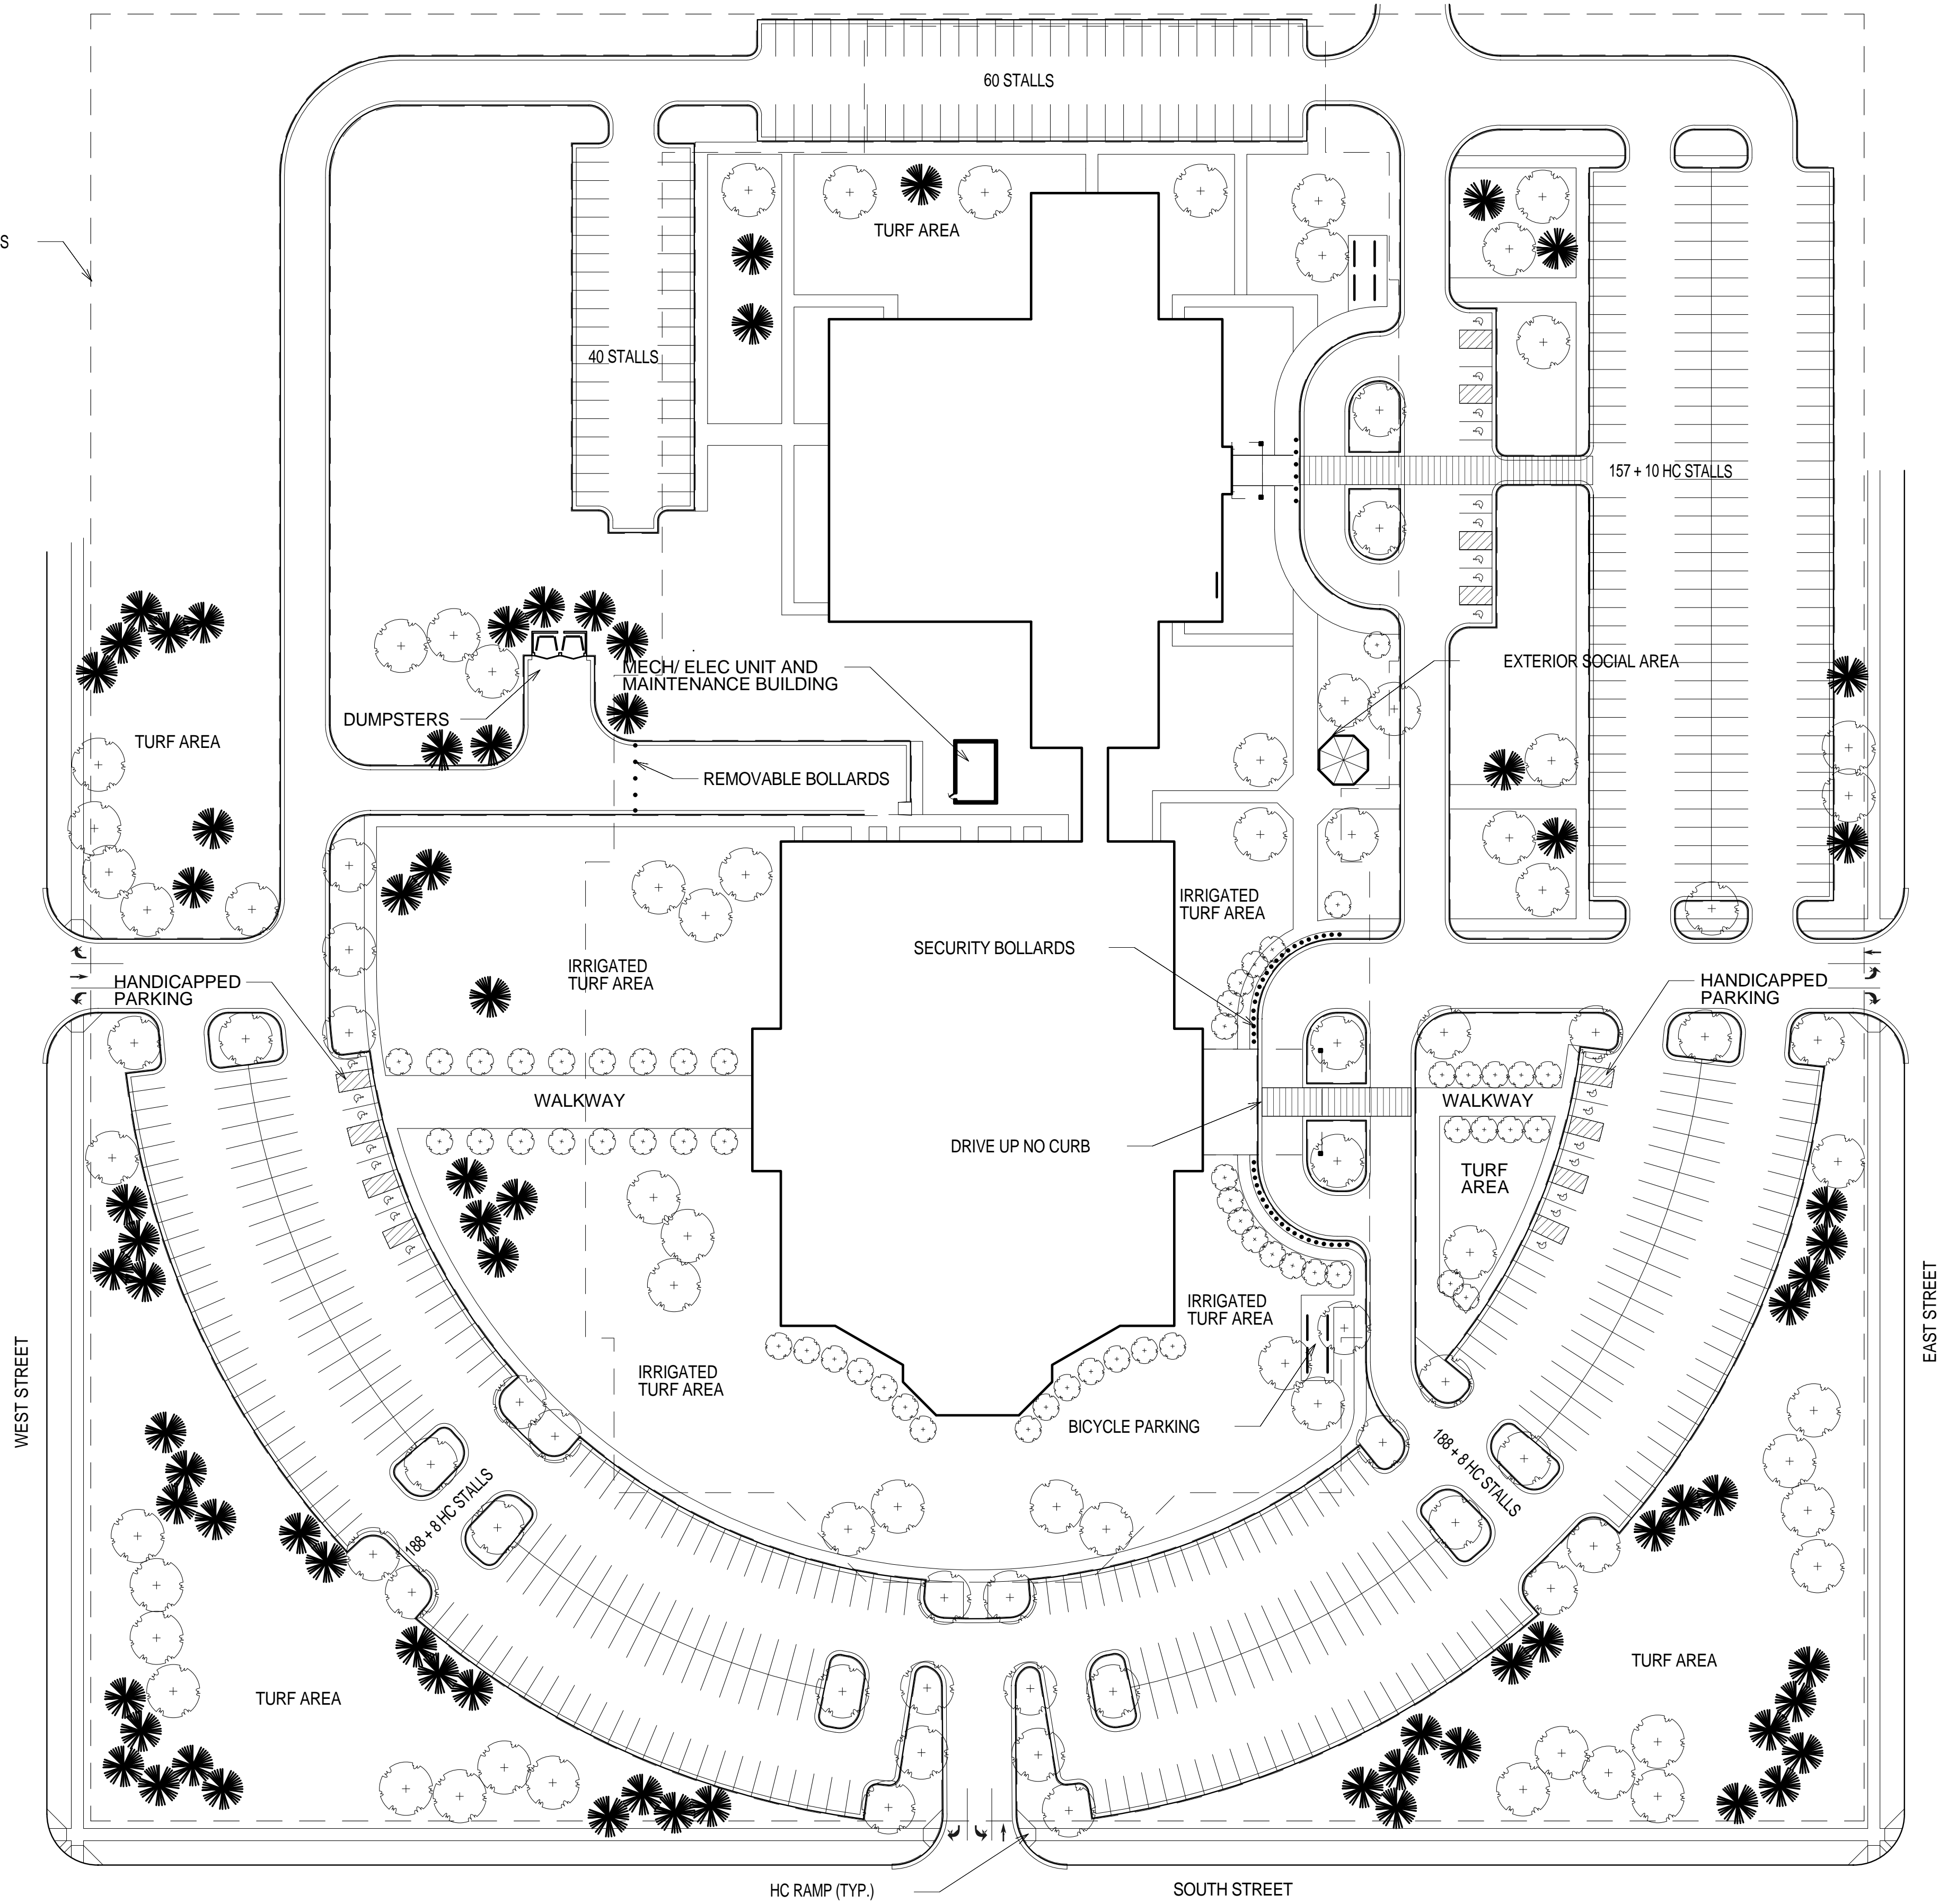

1 COMPOSITE SITE PLAN ALT-2

C-102 1" = 50'-0"



DATE	DESCRIPTION	APPR.

DESIGN BY:	ISSUE DATE:
DESIGNED BY:	SOLICITATION NO.:
CHECKED BY:	CONTRACT NO.:
APPROVED BY:	FILE NUMBER:
DATE:	FILE NAME:
9/29/2013	22' x 34'
2:41:13 PM	
1" = 50'-0"	

US ARMY CORPS OF ENGINEERS
OMAHA DISTRICT

LARGE CHAPEL
3D BIM - ARMY STANDARD DESIGN
VARIOUS LOCATIONS (CONUS)
BASIC MINISTRY SERIES
COMPOSITE SITE PLAN ALT-2

SHEET IDENTIFICATION
C-102
SHEET 3 OF 0


1

2

3

4




5

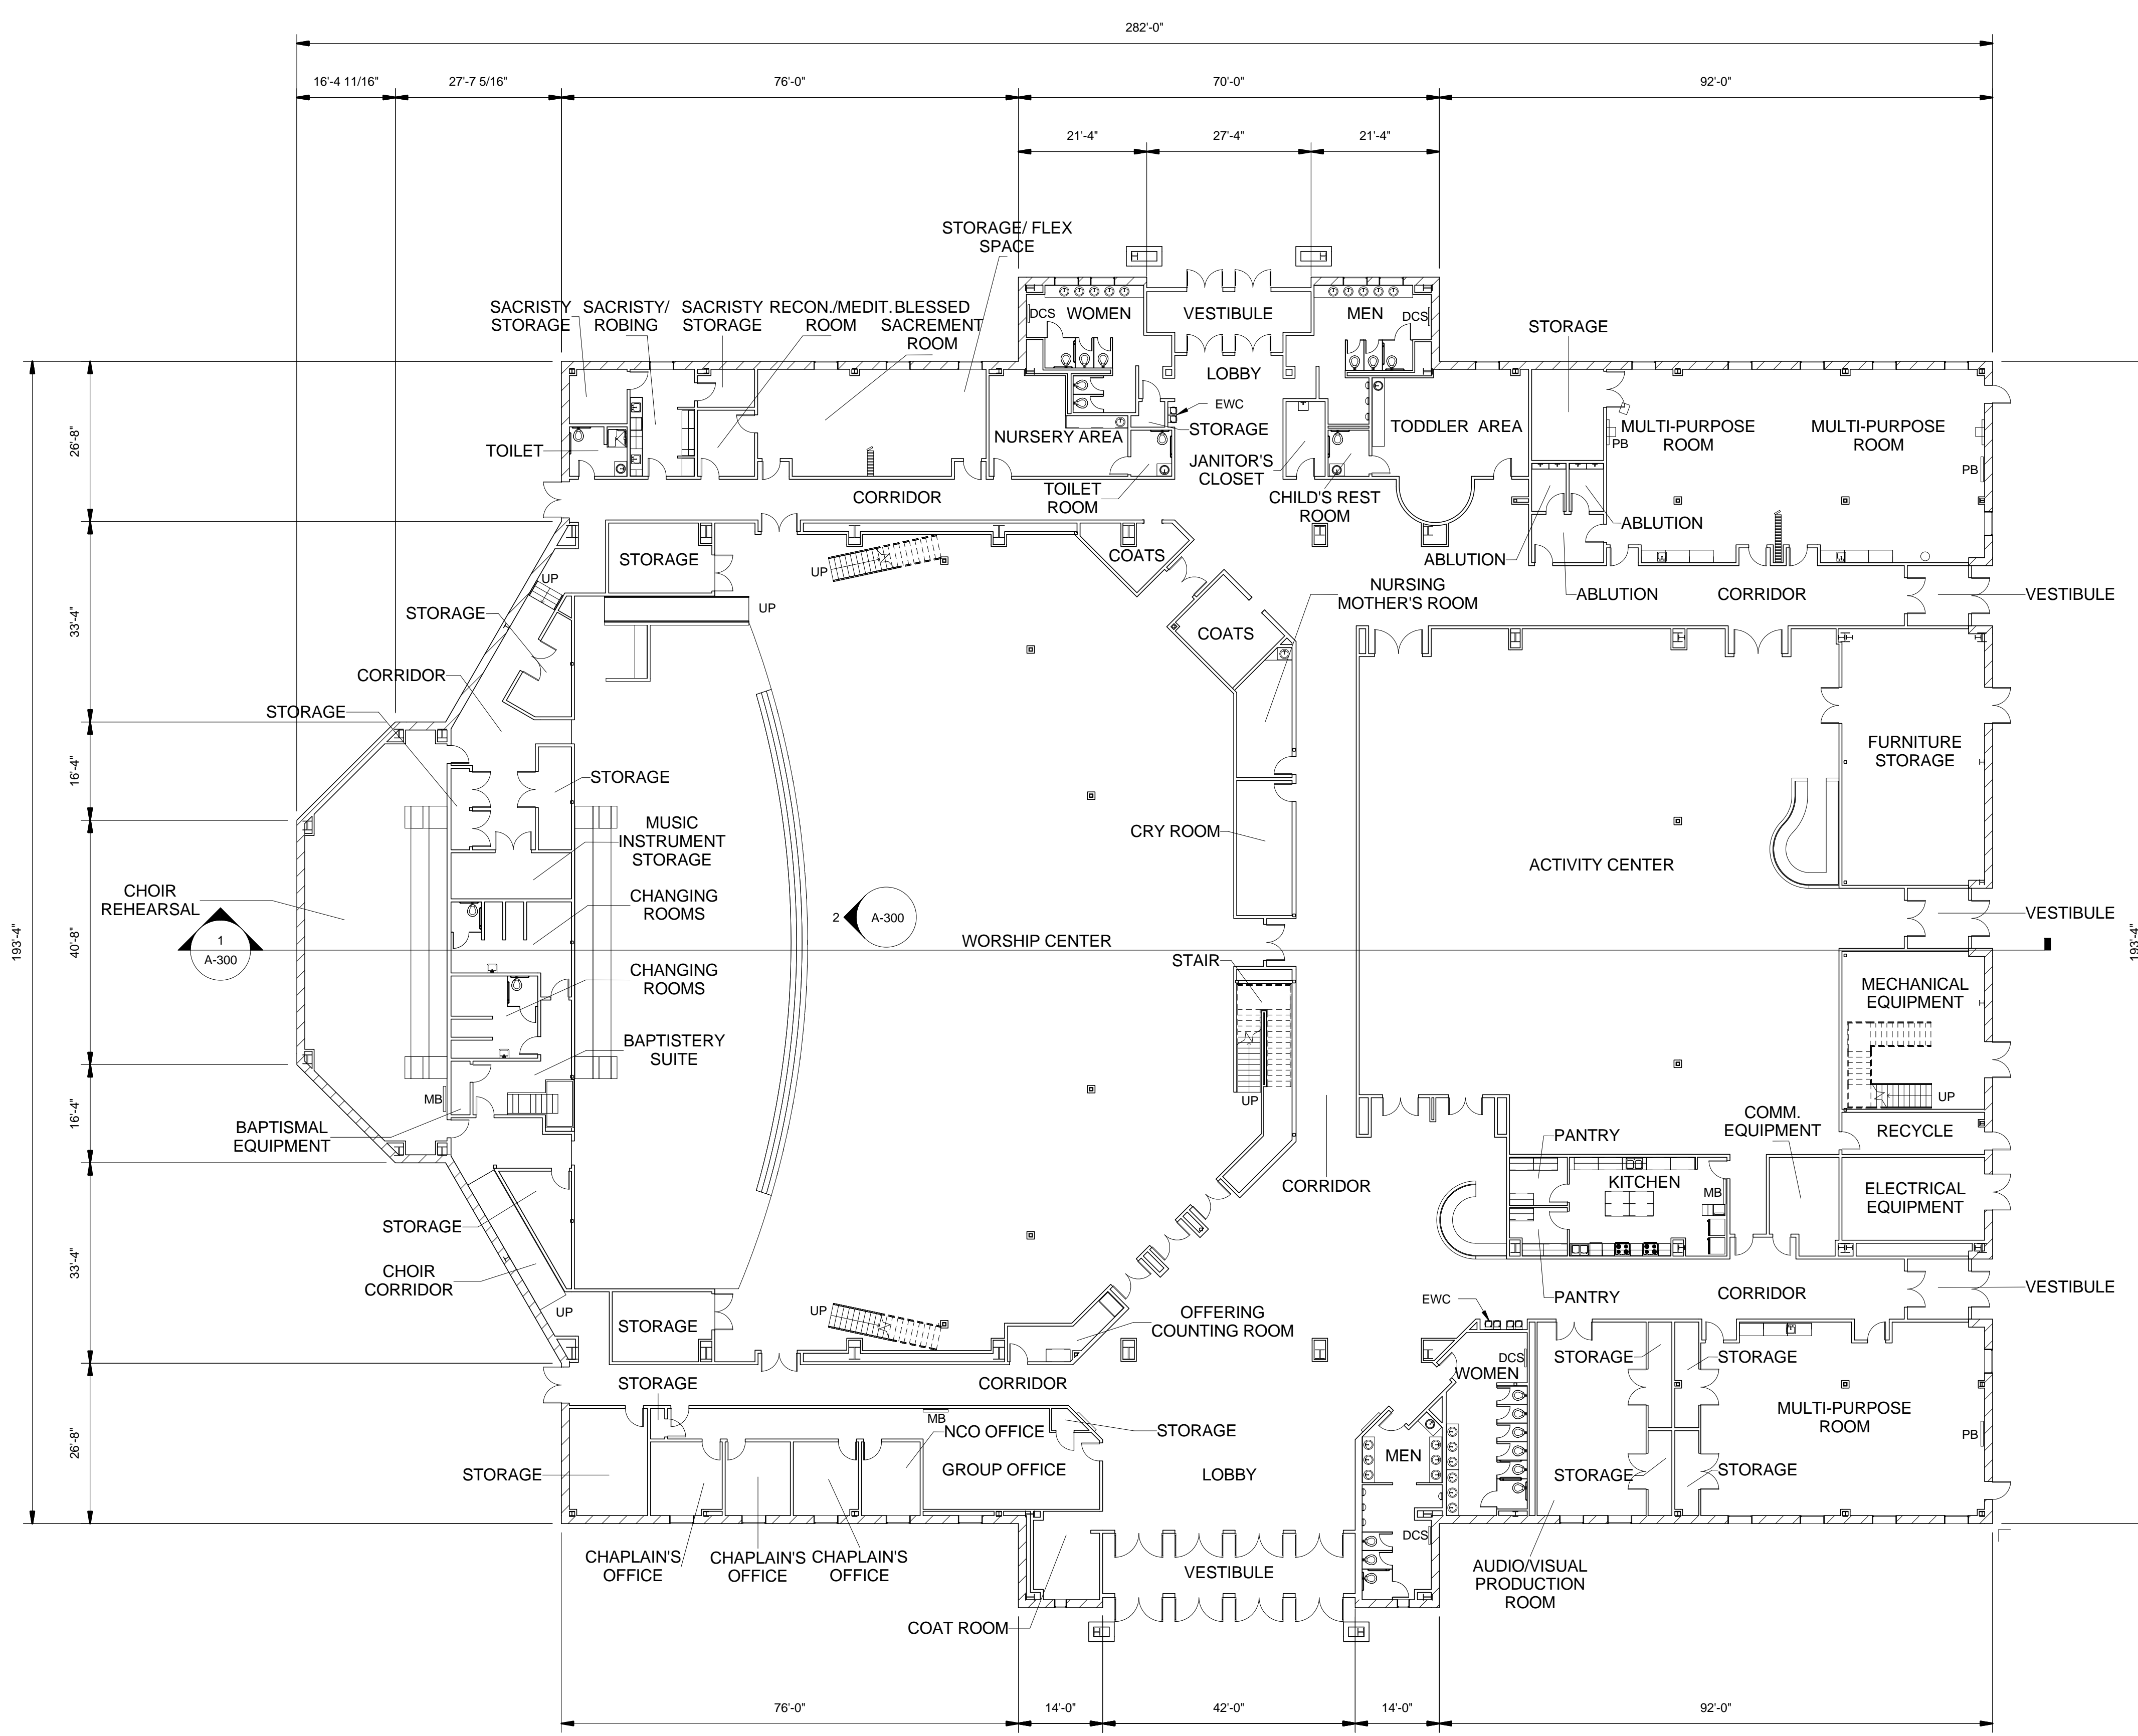

- GENERAL NOTES:**
1. REFER TO THE ARMY STANDARD AND ARMY STANDARD DESIGN DOCUMENTS FOR ALL FACILITY DESIGN REQUIREMENTS INCLUDING THOSE THAT MAY NOT BE ILLUSTRATED IN THESE PLANS.
 2. THE LOCATION AND NUMBER OF BUILDING ACCESSORIES (MARKER BOARDS, TACK BOARDS, TOILET ACCESSORIES, DIRECTORIES, ETC.) IS FLEXIBLE. PLEASE SEE ROOM FURNISHING REQUIREMENTS IN STANDARD DESIGN TEXT (AS WELL AS ANY APPLICABLE CODES AND CRITERIA) FOR SPECIFIC FURNISHING REQUIREMENTS. EACH INSTALLATION MAY ADD TO THESE REQUIRED FURNISHINGS TO THE EXTENT THAT THEY DO NOT CONFLICT WITH OTHER ARMY STANDARD DESIGN REQUIREMENTS.
 3. THE NUMBER AND LOCATION OF MEDIA CONSOLES IS FLEXIBLE BASED ON THE NEEDS OF EACH INSTALLATION AND USER GROUP. THIS DOCUMENT ILLUSTRATES SOME OF THE POSSIBLE LOCATIONS FOR MEDIA CONSOLES. THE BALCONY MEDIA CONTROL CONSOLE IS REQUIRED BY THE ARMY STANDARD, BUT ALL OTHERS MAY BE IMPLEMENTED AS REQUIRED TO SUIT INDIVIDUAL NEEDS.
 4. LOCATION OF OPTIONAL DROP CURTAIN AS REQUIRED PER SPECIFIC USER NEEDS.

PLAN LEGEND

- DCS DIAPER CHANGING STATION
- EWC ELECTRIC WATER COOLER
- MB MARKER BOARD
- PB PRESENTATION BOARD

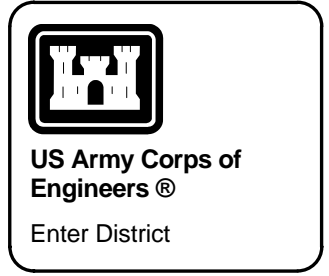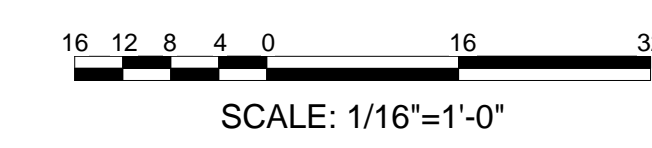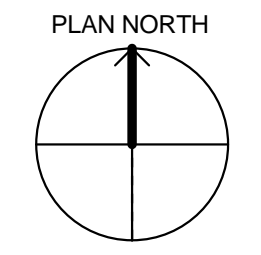

DATE	DESCRIPTION	MARK


DESIGN BY:	ISSUE DATE:	DESIGNATION NO.:
DESIGNED BY:		
CHECKED BY:		
APPROVED BY:		

LARGE CHAPEL
 3D BIM - ARMY STANDARD DESIGN
 VARIOUS LOCATIONS (CONUS)
 BASIC MINISTRY SERIES
 COMPOSITE FIRST FLOOR PLAN

SHEET IDENTIFICATION
A-110
 SHEET 4 OF 0

A A-110-XXX

1
COMPOSITE FIRST FLOOR PLAN
 1/16" = 1'-0"

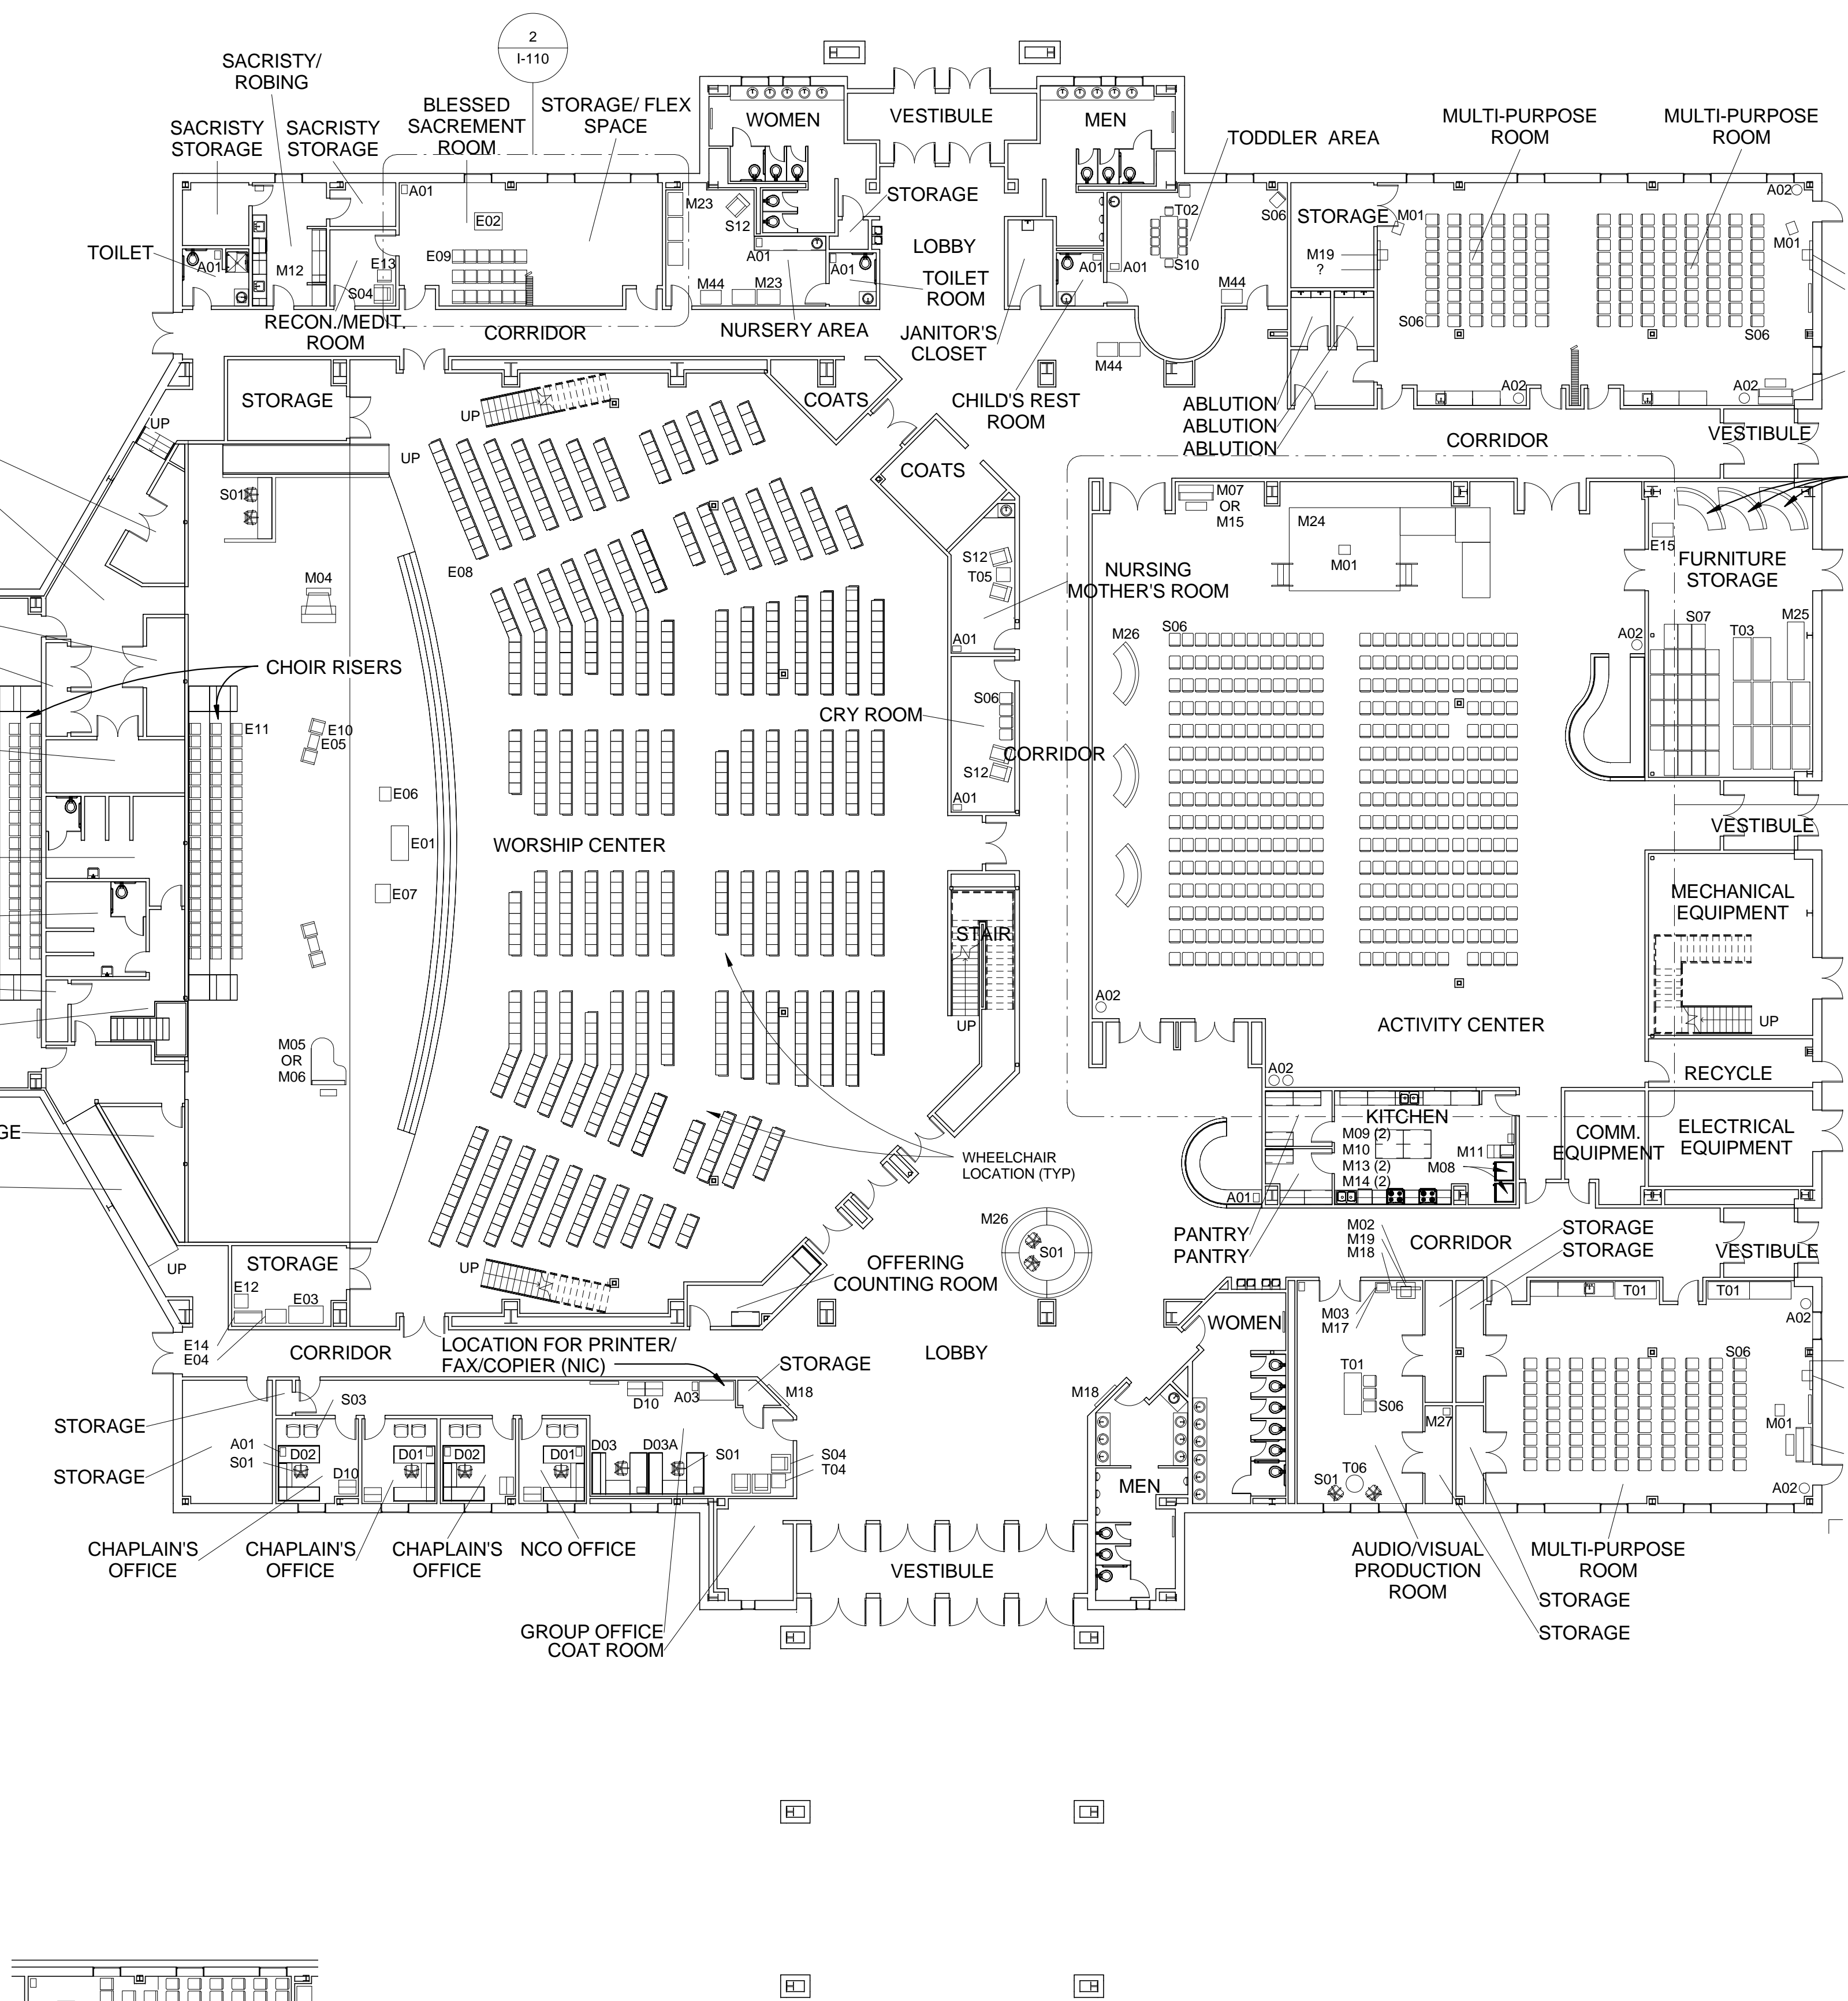


NOTES:

- 1. ITEMS IDENTIFIED WITH AN ASTERISK IN THE LEGEND ARE OPTIONAL. COORDINATE REQUIREMENTS WITH THE USER.
- 2. REFER TO STANDARD DESIGN FOR REQUIRED LOCATIONS OF MARKERBOARDS, PRESENTATION BOARDS, TV'S, MEDIA PLAYERS, TOILET RECEPTACLES AND SIMILAR TYPE ITEMS.
- 3. PROVIDE FURNITURE TO SUPPORT PRINTER/FAX/COPIER IN GROUP OFFICE IF EQUIPMENT IS NOT FREESTANDING. COORDINATE REQUIREMENT WITH USER.
- 4. PEW LAYOUT IS PROVIDED FOR INFORMATION ONLY. LAYOUT CAN BE REVISED AS LONG AS THE REQUIRED NUMBER OF SEATS ARE PROVIDED, PROJECT COST ISN'T INCREASED AND THE LAYOUT IS COORDINATED WITH AND APPROVED BY THE USER AND COS. LAYOUT SHALL COMPLY WITH STANDARD DESIGN PARAGRAPH 3.1.3 ACCESSIBILITY REQUIREMENTS AND PARAGRAPH 3.1.3 FIRE PROTECTION REQUIREMENTS.

FURNITURE AND EQUIPMENT LEGEND

- ECCLESIASTICAL EQUIPMENT:**
E01 ALTAR
E02 ALTAR SMALL
E03 COMMUNION TABLE*
E04 CRESCENCE TABLE*
E05 OFFERTORY TABLE
E06 LECTERN
E07 PULPIT
E08 PEW
E09 STACKING PEW CHAIR W/ KNEELER
E10 CHANCEL CHAIR
E11 STACKING CHAIR FOR CHOIR
E12 BAPTISMAL FONT
E13 KNEELER/PRIE DIEU W/ SCREEN
E14 ALTAR RAIL UNIT
E15 PORTABLE ALTAR
- ACCESSORIES:**
A01 SMALL TRASH RECEPTACLE
A02 LARGE TRASH RECEPTACLE
A03 PAPER RECYCLE RECEPTACLE
A04 TOILET RECEPTACLE
- DESKS AND STORAGE:**
D01 U-SHAPED WORKSTATION, R-RETURN
D02 U-SHAPED WORKSTATION, L-RETURN
D03 ADMINISTRATIVE WORKSTATION
D03A ADMINISTRATIVE WORKSTATION, A-TYPICAL
D04 - D09 NOT USED
D10 LATERAL FILE W/ SHELVING
- MISCELLANEOUS:**
M01 PORTABLE PODIUM
M02 MEDIUM EQUIPMENT CART
M03 SMALL EQUIPMENT CART
M04 ORGAN
M05 GRAND PIANO
M06 BABY GRAND PIANO
M07 UPRIGHT PIANO
M08 REFRIGERATOR
M09 RANGE
M10 DISHWASHER
M11 ICE MACHINE
M12 UNDERCOUNTER REFRIGERATOR
M13 MICROWAVE
M14 WARMING DRAWERS
M15 KEYBOARD/SYNTHESIZER
M16 OUTDOOR FURNITURE*
M17 PORTABLE PROJECTOR
M18 TV, FLAT SCREEN
M19 MEDIA PLAYER
M20 - M22 NOT USED
M23 CRIB
M24 STAGE
M25 STAGE DOLLY
M26 KIOSK
M27 PORTABLE PROJECTION SCREEN
M44 CHILD CHECK-IN SYSTEM AND CART
- SEATING:**
S01 DESK CHAIR
S02 NOT USED
S03 GUEST CHAIR
S04 LOUNGE CHAIR
S05 NOT USED
S06 STACKING CHAIR
S07 STACKING CHAIR DOLLY
S08 - S09 NOT USED
S10 SMALL CHILDREN'S CHAIR
S11 NOT USED
S12 ROCKER/GLIDER
- TABLES:**
T01 MULTI-PURPOSE TABLE, 72" X 30"
T02 CHILDREN'S TABLE
T03 TABLE DOLLY (72" X 30" TABLE)
T04 LOBBY END TABLE
T05 END TABLE
T06 30" DIA TABLE

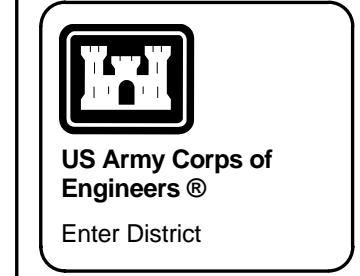


DATE	DESCRIPTION	MARK

DESIGN BY:	ISSUE DATE:
DESIGNER:	DATE:
DATE:	DATE:
FILE NAME:	FILE NUMBER:
FILE NUMBER:	FILE NUMBER:
FILE NUMBER:	FILE NUMBER:
US ARMY CORPS OF ENGINEERS
OMAHA DISTRICT

LARGE CHAPEL
3D BIM - ARMY STANDARD DESIGN
VARIOUS LOCATIONS (CONUS)
BASIC MINISTRY SERIES
COMPOSITE FIRST FLOOR
FURNITURE PLAN

SHEET IDENTIFICATION
I-110
SHEET 7 OF 8

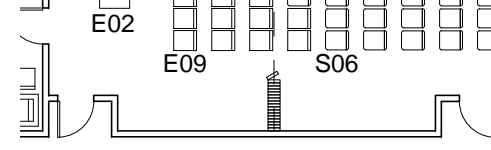


1 COMPOSITE FIRST FLOOR FURNITURE PLAN

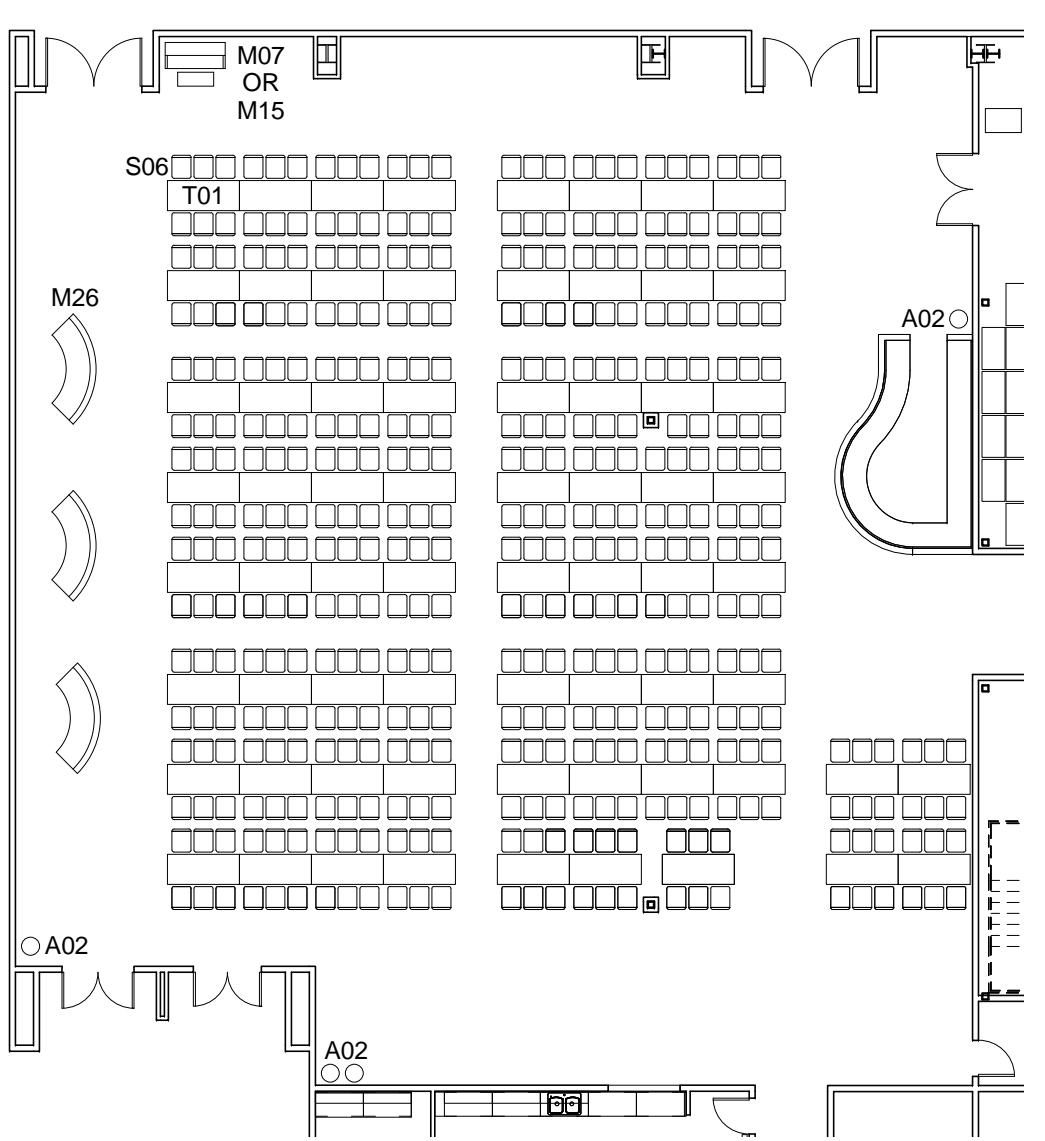

3 ACTIVITY CENTER ALTERNATE LAYOUT

2 BLESSED SACRAMENT ALTERNATE LAYOUT

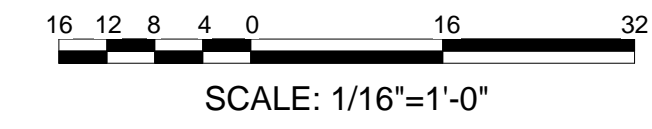

I-110

1-120


1

2

3

4

5

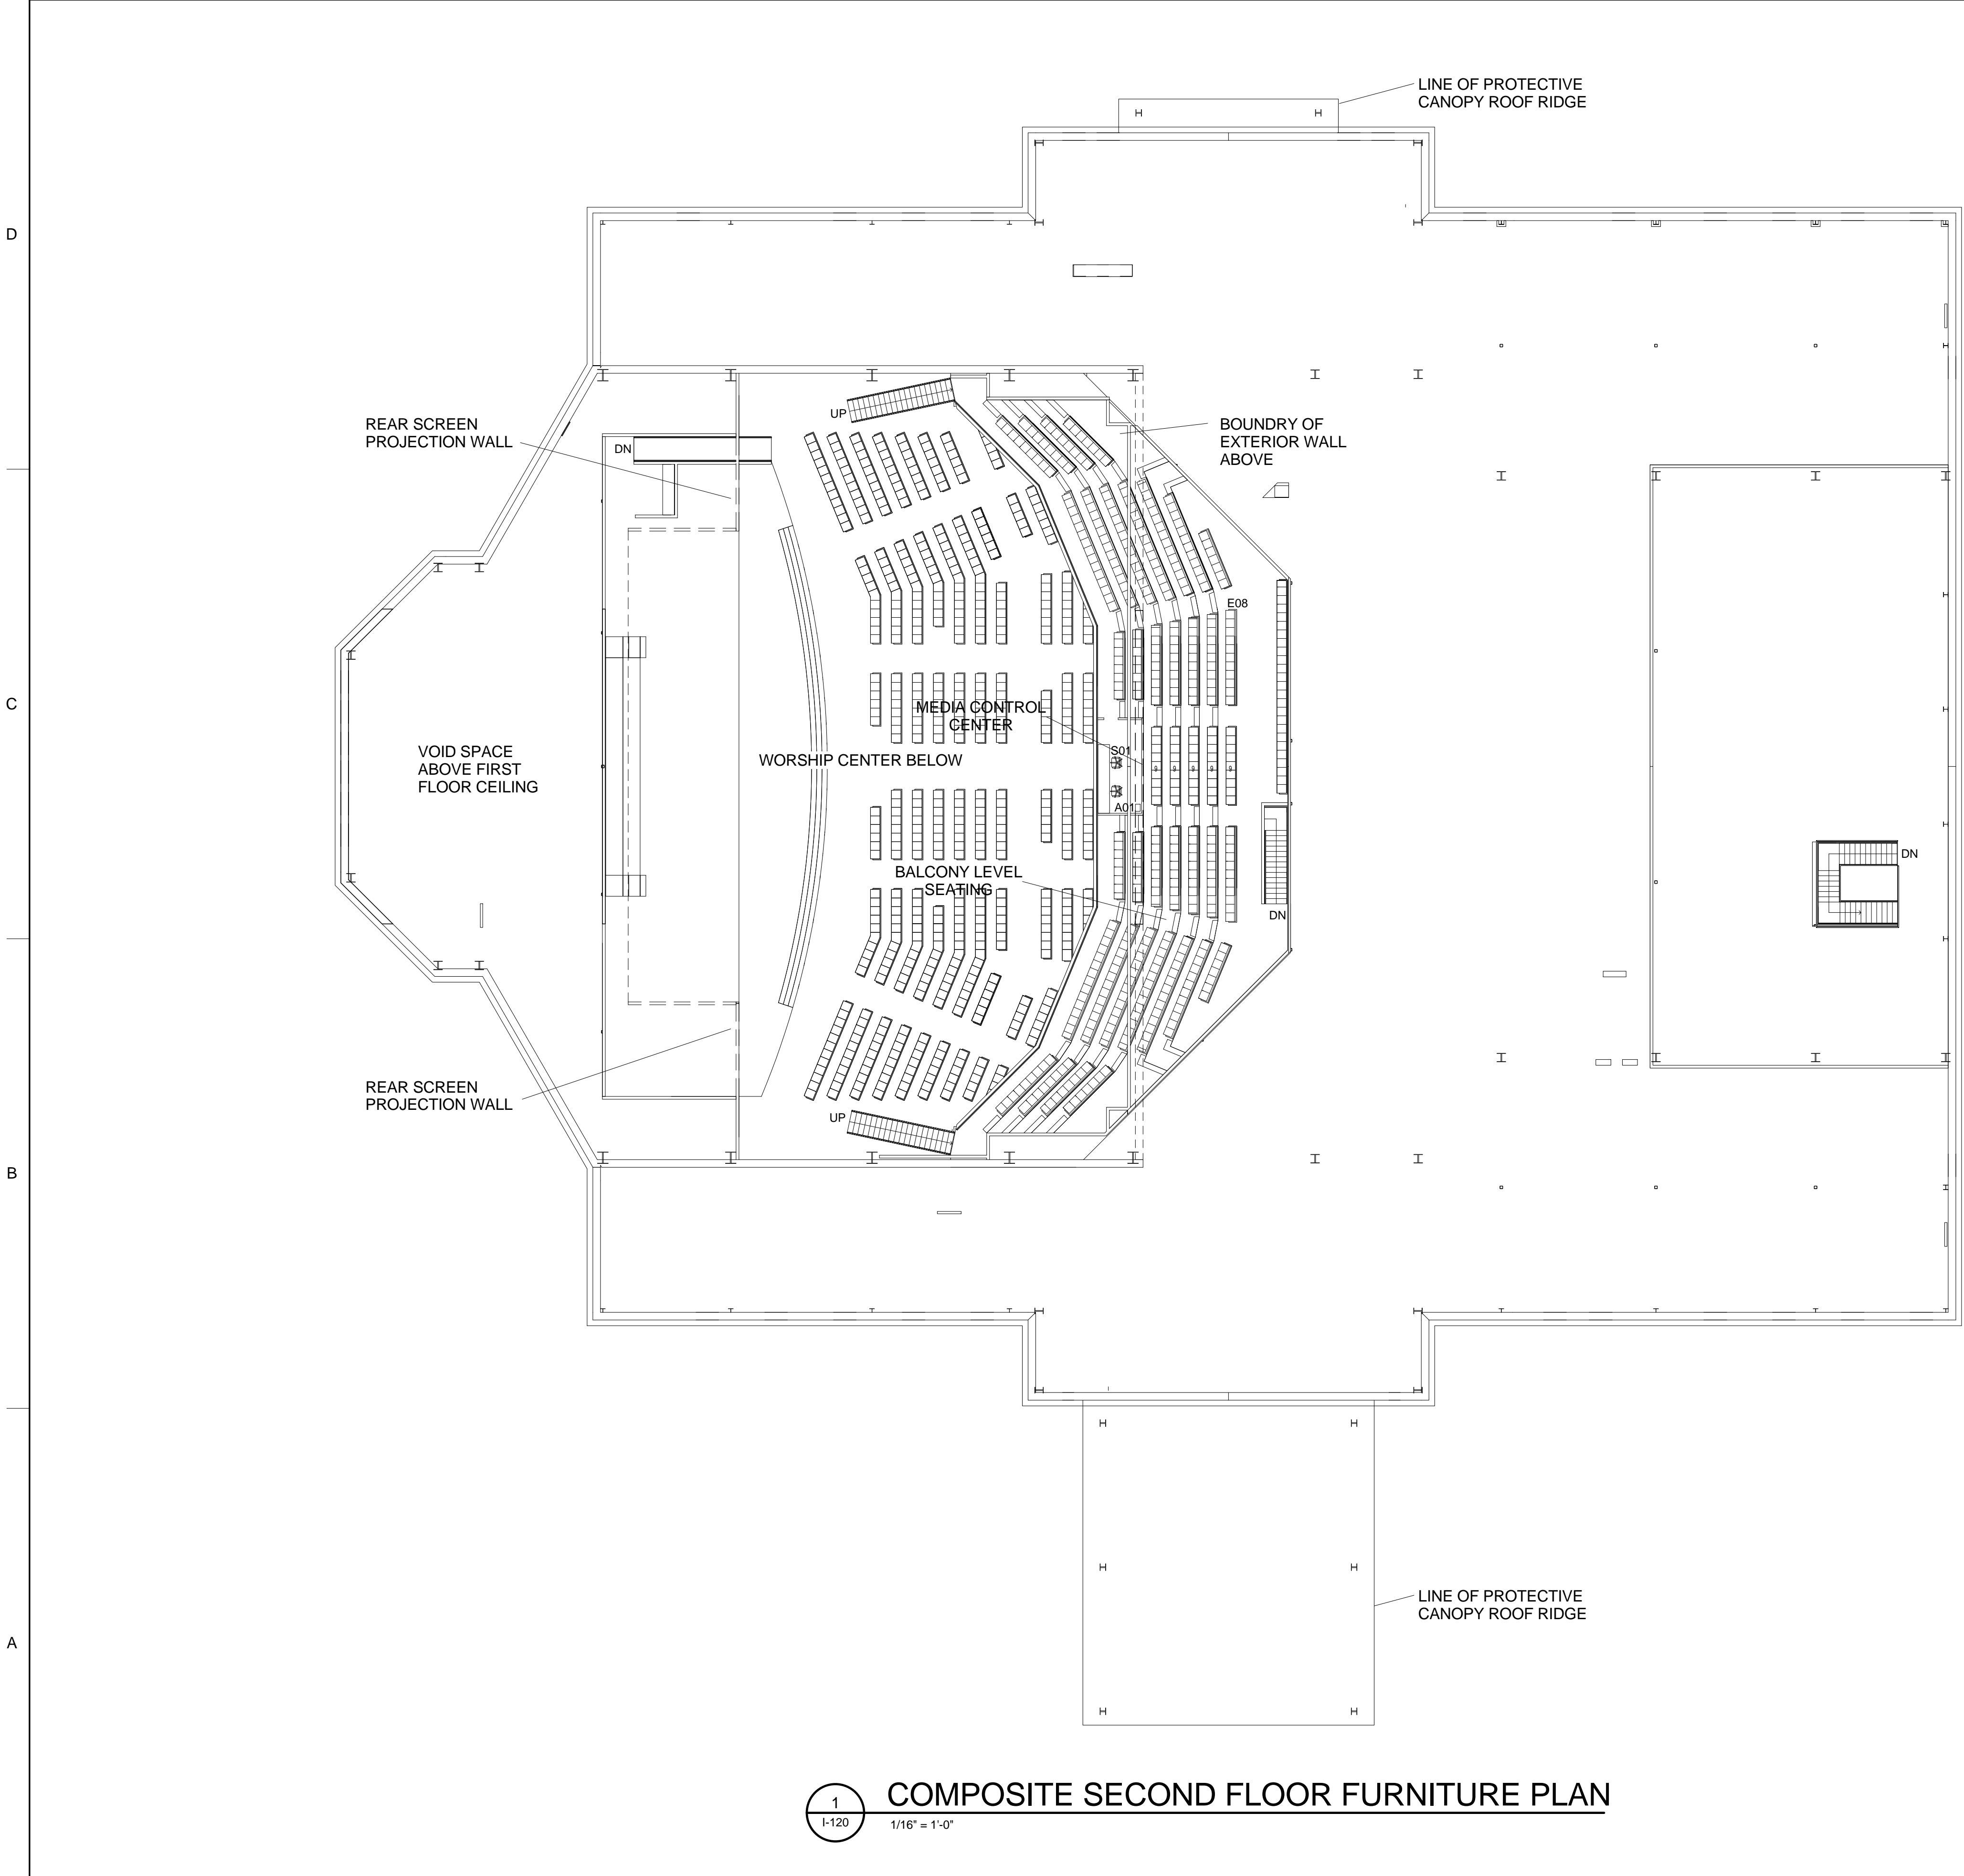

FURNITURE AND EQUIPMENT LEGEND

- ECCLESIASTICAL EQUIPMENT:
E01 ALTAR
E02 ALTAR SMALL
E03 COMMUNION TABLE*
E04 CREDENCE TABLE*
E05 OFFERTORY TABLE
E06 LECTERN
E07 PULPIT
E08 PEW
E09 STACKING PEW CHAIR W/ KNEELER
E10 CHANCEL CHAIR
E11 STACKING CHAIR FOR CHOIR
E12 BAPTISMAL FONT
E13 KNEELER/PRIE DIEU W/ SCREEN
E14 ALTAR RAIL UNIT
E15 PORTABLE ALTAR

- ACCESSORIES:
A01 SMALL TRASH RECEPTACLE
A02 LARGE TRASH RECEPTACLE
A03 PAPER RECYCLE RECEPTACLE
A04 TOILET RECEPTACLE

- DESKS AND STORAGE:
D01 U-SHAPED WORKSTATION, R-RETURN
D02 U-SHAPED WORKSTATION, L-RETURN
D03 ADMINISTRATIVE WORKSTATION
D03A ADMINISTRATIVE WORKSTATION, A-TYPICAL
D04 - D09 NOT USED
D10 LATERAL FILE W/ SHELVING


- MISCELLANEOUS:
M01 PORTABLE PODIUM
M02 MEDIUM EQUIPMENT CART
M03 SMALL EQUIPMENT CART
M04 ORGAN
M05 GRAND PIANO
M06 BABY GRAND PIANO
M07 UPRIGHT PIANO
M08 REFRIGERATOR
M09 RANGE
M10 DISHWASHER
M11 ICE MACHINE
M12 UNDERCOUNTER REFRIGERATOR
M13 MICROWAVE
M14 WARMING DRAWERS
M15 KEYBOARD/SYNTHESIZER
M16 OUTDOOR FURNITURE*
M17 PORTABLE PROJECTOR
M18 TV, FLAT SCREEN
M19 MEDIA PLAYER
M20 - M22 NOT USED
M23 CRIB
M24 STAGE
M25 STAGE DOLLY
M26 KIOSK
M27 PORTABLE PROJECTION SCREEN
M44 CHILD CHECK-IN SYSTEM AND CART

- SEATING:
S01 DESK CHAIR
S02 NOT USED
S03 GUEST CHAIR
S04 LOUNGE CHAIR
S05 NOT USED
S06 STACKING CHAIR
S07 STACKING CHAIR DOLLY
S08 - S09 NOT USED
S10 SMALL CHILDREN'S CHAIR
S11 NOT USED
S12 ROCKER/GLIDER

- TABLES:
T01 MULTI-PURPOSE TABLE, 72" X 30"
T02 CHILDREN'S TABLE
T03 TABLE DOLLY (72" X 30" TABLE)
T04 LOBBY END TABLE
T05 END TABLE
T06 30" DIA TABLE

NOTES:

1. ITEMS IDENTIFIED WITH AN ASTERISK IN THE LEGEND ARE OPTIONAL. COORDINATE REQUIREMENTS WITH THE USER.
2. REFER TO STANDARD DESIGN FOR REQUIRED LOCATIONS OF MARKERBOARDS, PRESENTATION BOARDS, TV'S, MEDIA PLAYERS, TOILET RECEPTACLES AND SIMILAR TYPE ITEMS.
3. PEW LAYOUT IS PROVIDED FOR INFORMATION ONLY. LAYOUT CAN BE REVISED AS LONG AS THE REQUIRED NUMBER OF SEATS ARE PROVIDED, PROJECT COST ISN'T INCREASED AND THE LAYOUT IS COORDINATED WITH AND APPROVED BY THE USER AND COS. LAYOUT SHALL COMPLY WITH STANDARD DESIGN PARAGRAPH 3.1.3 ACCESSIBILITY REQUIREMENTS AND PARAGRAPH 3.13 FIRE PROTECTION REQUIREMENTS.

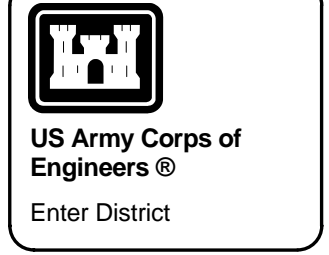

DATE	APPR	MARK	DESCRIPTION

DESIGN BY: LCH	DESIGN DATE: 9/26/13	DESIGNED BY: WRB	CHECKED BY: WRB	ISSUE DATE: 9/26/13	ISSUED BY: WRB	SOLICITATION NO.:	CONTRACT NO.:	FILE NUMBER:
US ARMY CORPS OF ENGINEERS			OMAHA DISTRICT			FILE NAME: 22' x 34'		

LARGE CHAPEL
3D BIM - ARMY STANDARD DESIGN
VARIOUS LOCATIONS (CONUS)
BASIC MINISTRY SERIES
COMPOSITE SECOND FLOOR
FURNITURE PLAN

SHEET IDENTIFICATION
I-120
SHEET 8 OF 0

1 COMPOSITE SECOND FLOOR FURNITURE PLAN
1-120 1/16" = 1'-0"

