
SMALL RELIGIOUS EDUCATION FACILITY

ARMY STANDARD DESIGN


VARIOUS LOCATIONS (CONUS)

DESIGN FILE	DRAWING NUMBER	SHEET NUMBER	DESCRIPTION
RF_ESG-101.DGN	G-101	1	COVER SHEET AND INDEX
RF_ESC-100.DGN	C-100	2	SMALL RELIGIOUS EDUCATION FACILITY GENERIC SITE PLAN
RF_ESA-100.DGN	A-100	3	SMALL RELIGIOUS EDUCATION FACILITY FLOOR PLAN
RF_ESA-200.DGN	A-200	4	SMALL RELIGIOUS EDUCATION FACILITY BUILDING ELEVATIONS
RF_ESI-100.DGN	I-100	5	SMALL RELIGIOUS EDUCATION FACILITY FURNITURE LAYOUT

THIS PROJECT WAS DESIGNED BY THE OMAHA DISTRICT OF THE US ARMY CORPS OF ENGINEERS. THE INITIALS OR SIGNATURES AND REGISTRATION DESIGNATIONS OF INDIVIDUALS APPEAR ON THESE PROJECT DOCUMENTS WITHIN THE SCOPE OF THEIR EMPLOYMENT AS REQUIRED BY ER 1110-1-8152.

THE FOLLOWING SIGNATURES BELOW INDICATE OFFICIAL APPROVAL OF ALL DRAWINGS IN THIS SET DATED _____

SUBMITTED BY:	RA
CHIEF: ARCH	SECTION
SUBMITTED BY:	PE
CHIEF: CIVIL	SECTION
SUBMITTED BY:	PE
CHIEF: ELECT	SECTION
SUBMITTED BY:	PE
CHIEF: ENVIR	SECTION
SUBMITTED BY:	PE
CHIEF: MECH	SECTION
SUBMITTED BY:	PE
CHIEF: STRUCT/INTER	SECTION
SUBMITTED BY:	PE
CHIEF: GEOT	SECTION
SUBMITTED BY: CADD	PROJECT COORD.

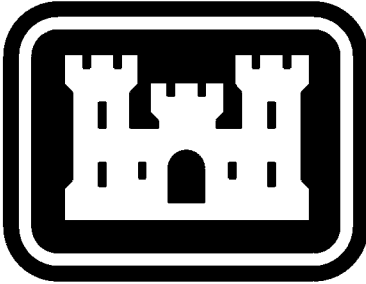


US Army Corps
of Engineers
Omaha District


D



 ARMY RELIGIOUS EDUCATION FACILITY




G6EDXTJD

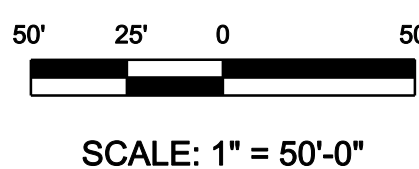[illegible]


CORPS OF ENGINEERS OMAHA, NEBRASKA	DRAW BY:	JUD	CONTRACT NO.:	Z
	DATE:	1/10	SOLICITATION NO.:	Z
	SUBMITTED BY:	X	FILE NUMBER:	
	PLOT SCALE:	1" = 50'	FILE NAME:	
SIZE:		8 1/2" x 11" / n.		

3D BIM TRANSLATION ARMY STANDARD DESIGN RELIGIOUS EDUCATION FACILITY SMALL RELIGIOUS EDUCATION FACILITY GENERIC SITE PLAN


SHEET
IDENTIFICATION
C-100

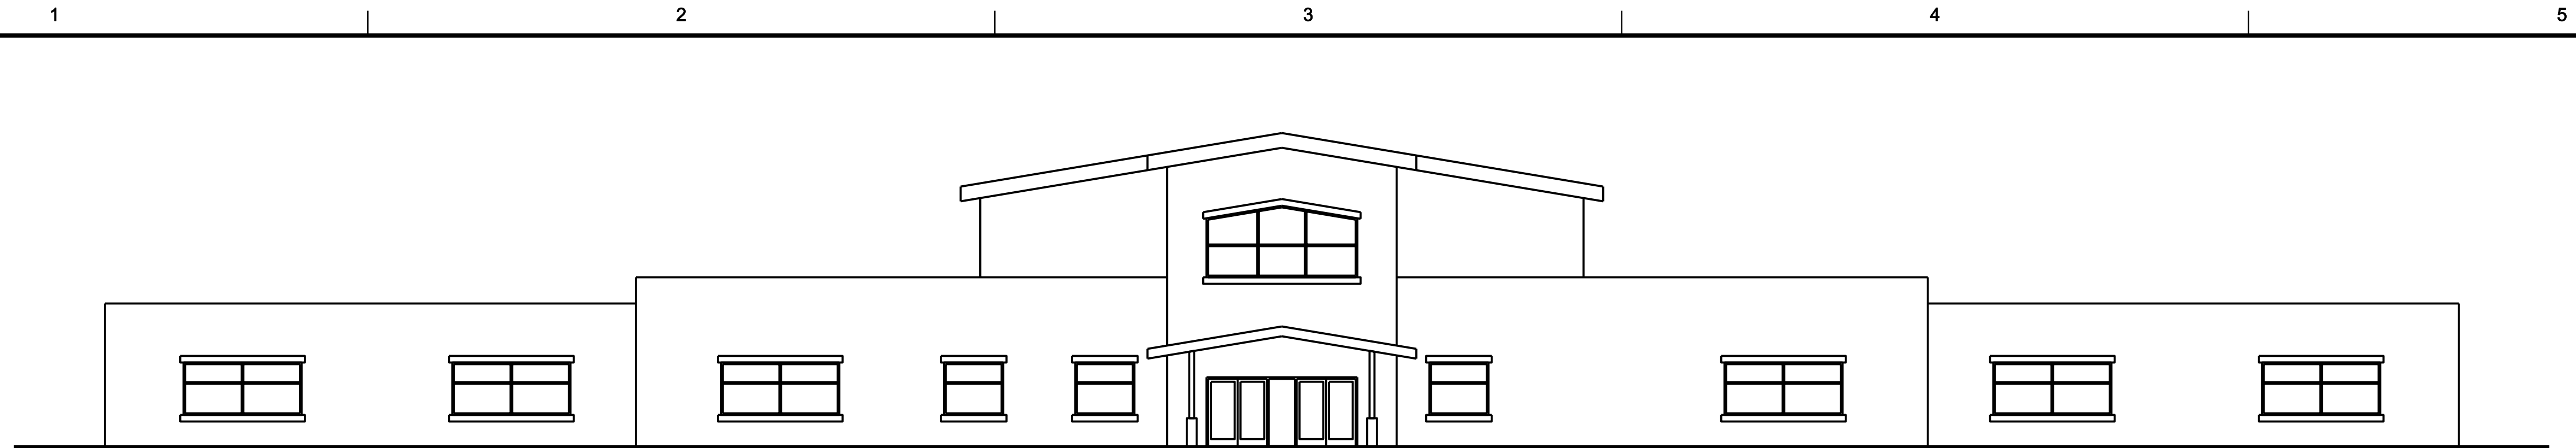


1 BUILDING ELEVATION

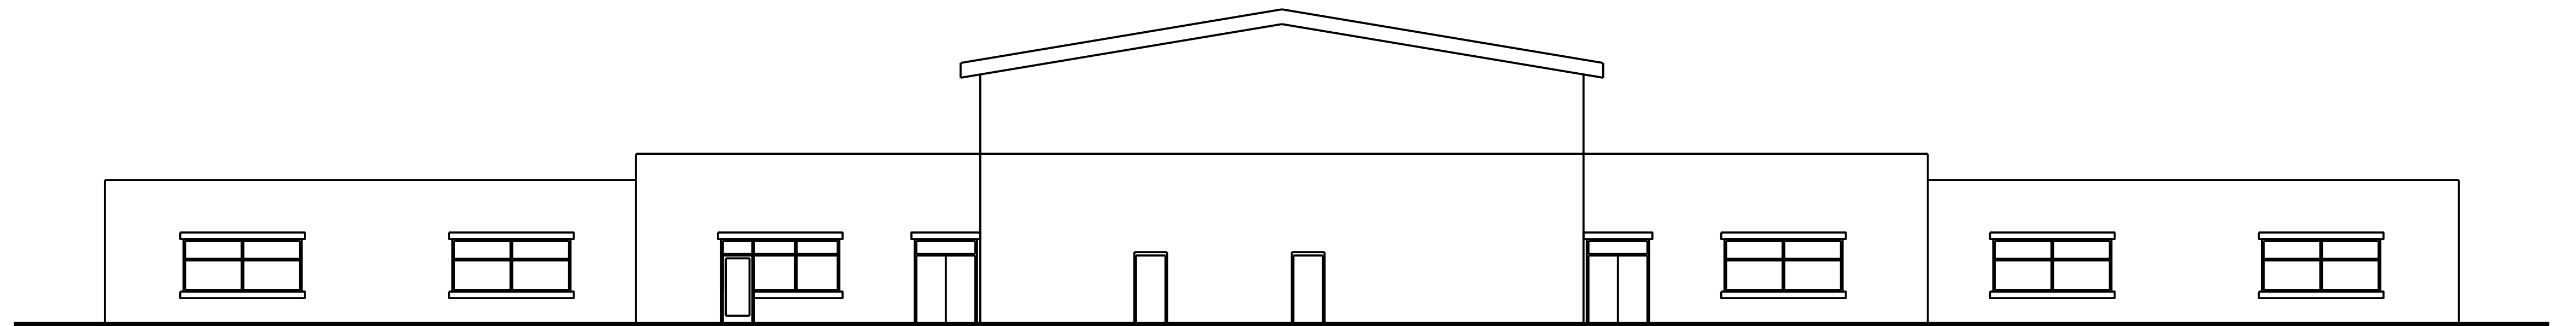


2 BUILDING ELEVATION
A-100 3/32" = 1' 0"

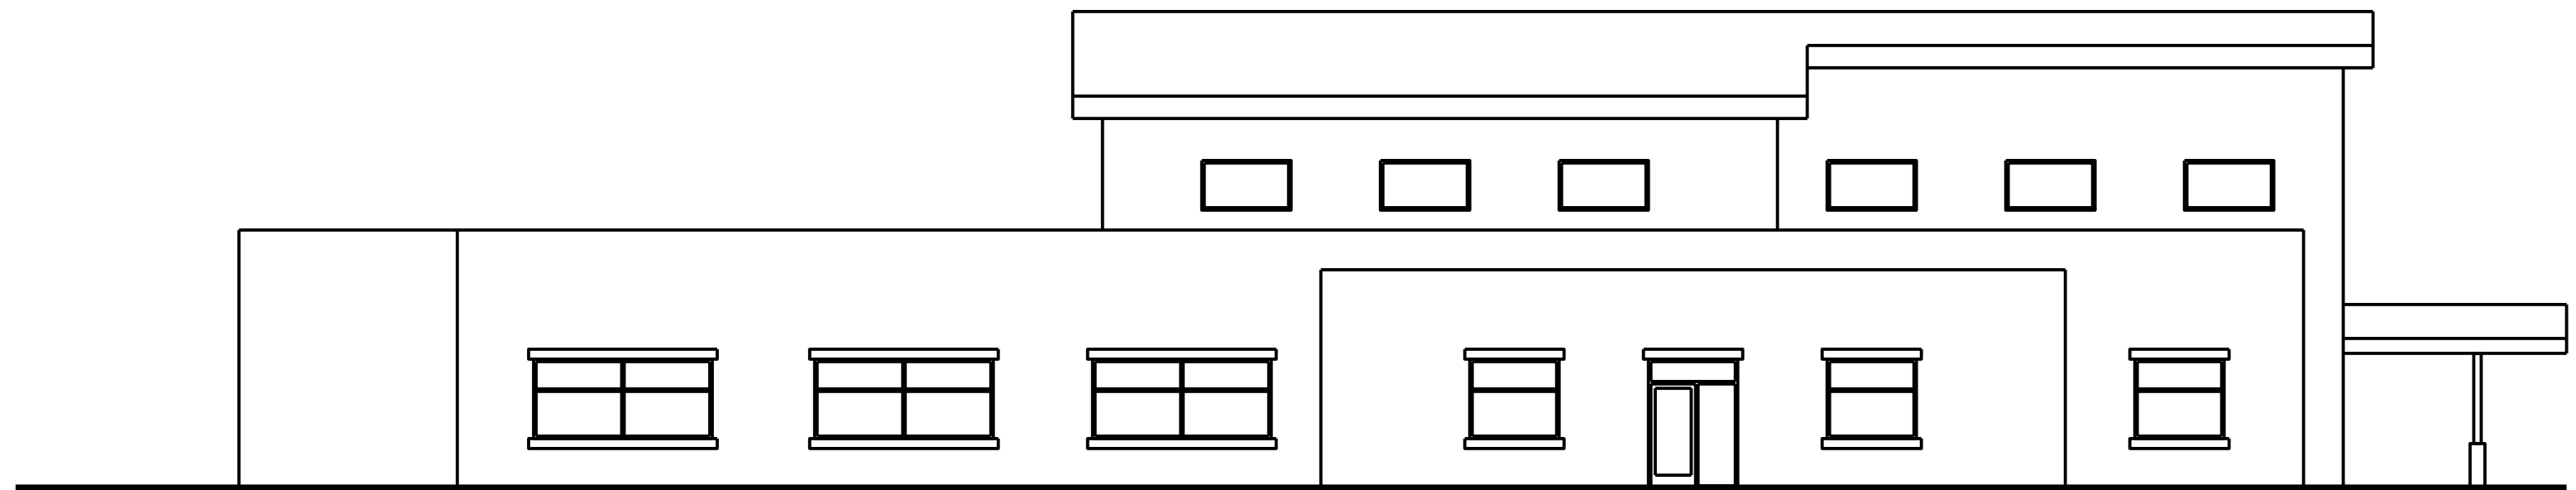

3 BUILDING ELEVATION
A-100 3/32" = 1' 0"

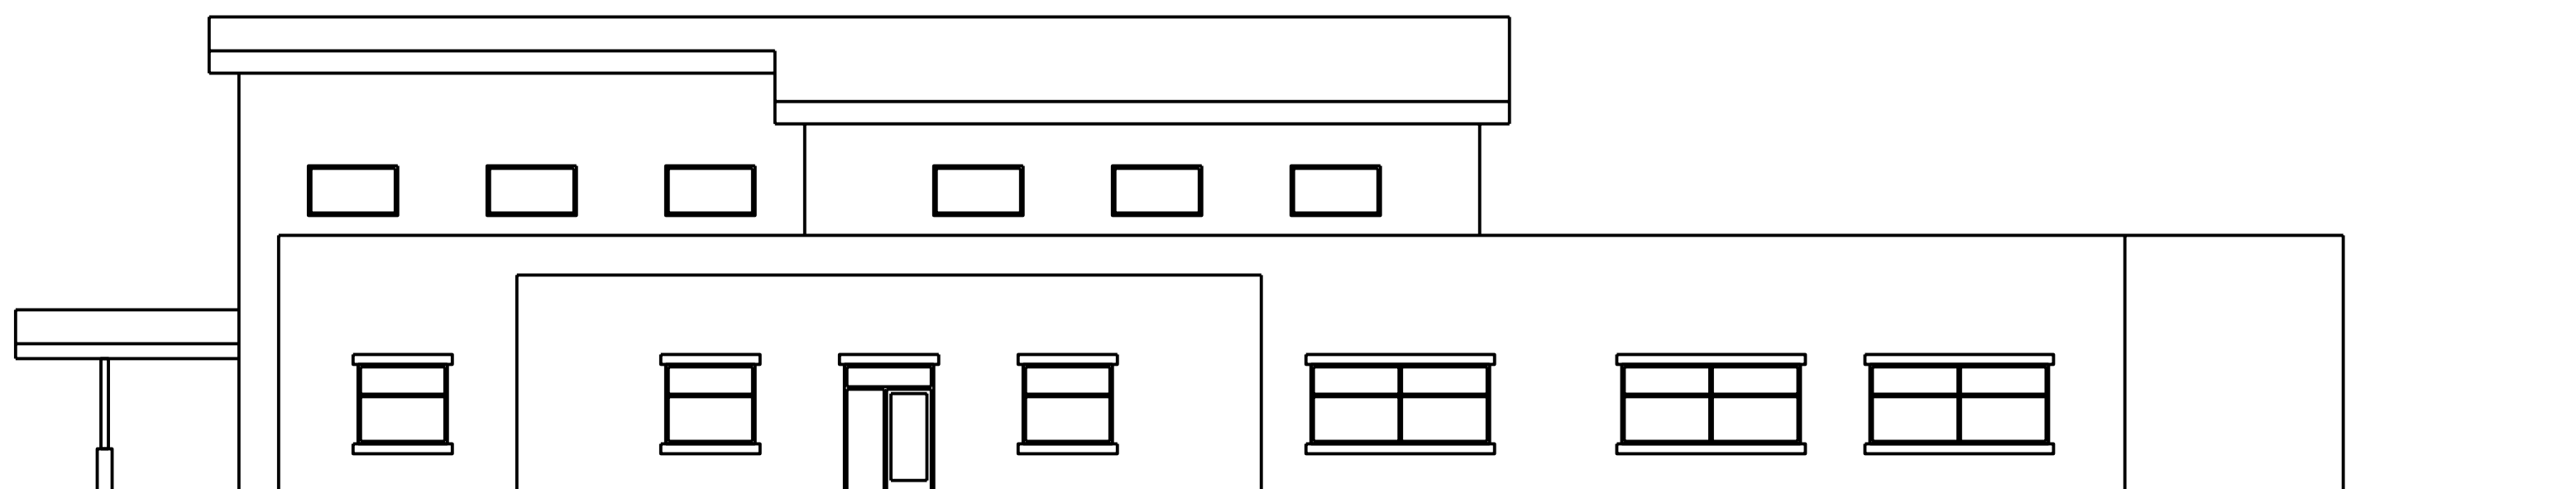

4 BUILDING ELEVATION
A-100 3/32" = 1' 0"

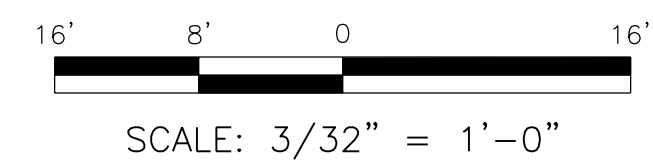

**US Army Corps
of Engineers®**
OMAHA DISTRICT

[illegible]

US ARMY ENGINEER DISTRICT CORPS OF ENGINEERS OMAHA, NEBRASKA	DESIGNED BY:	X	DRAWN BY:	X	SOLICITATION NO.:	Z
	CHECKED BY:		ACQ BY:	X	CONTRACT NO.:	
	PLOTTED BY:	X			FILE NUMBER:	Z
	SHEET SCALE:		PLOT DATE:	01 Jun / in 8/16/2012		
	SIZE:		FILE NAME:	RF_ESA-200.dgn		

VARIOUS LOCATIONS
3D BIM TRANSLATION
ARMY STANDARD DESIGN
RELIGIOUS EDUCATION FACILITY

SMALL RELIGIOUS EDUCATION FACILITY
BUILDING ELEVATIONS

**SHEET
IDENTIFICATION**

A-200

